



Floorplan. 1:200

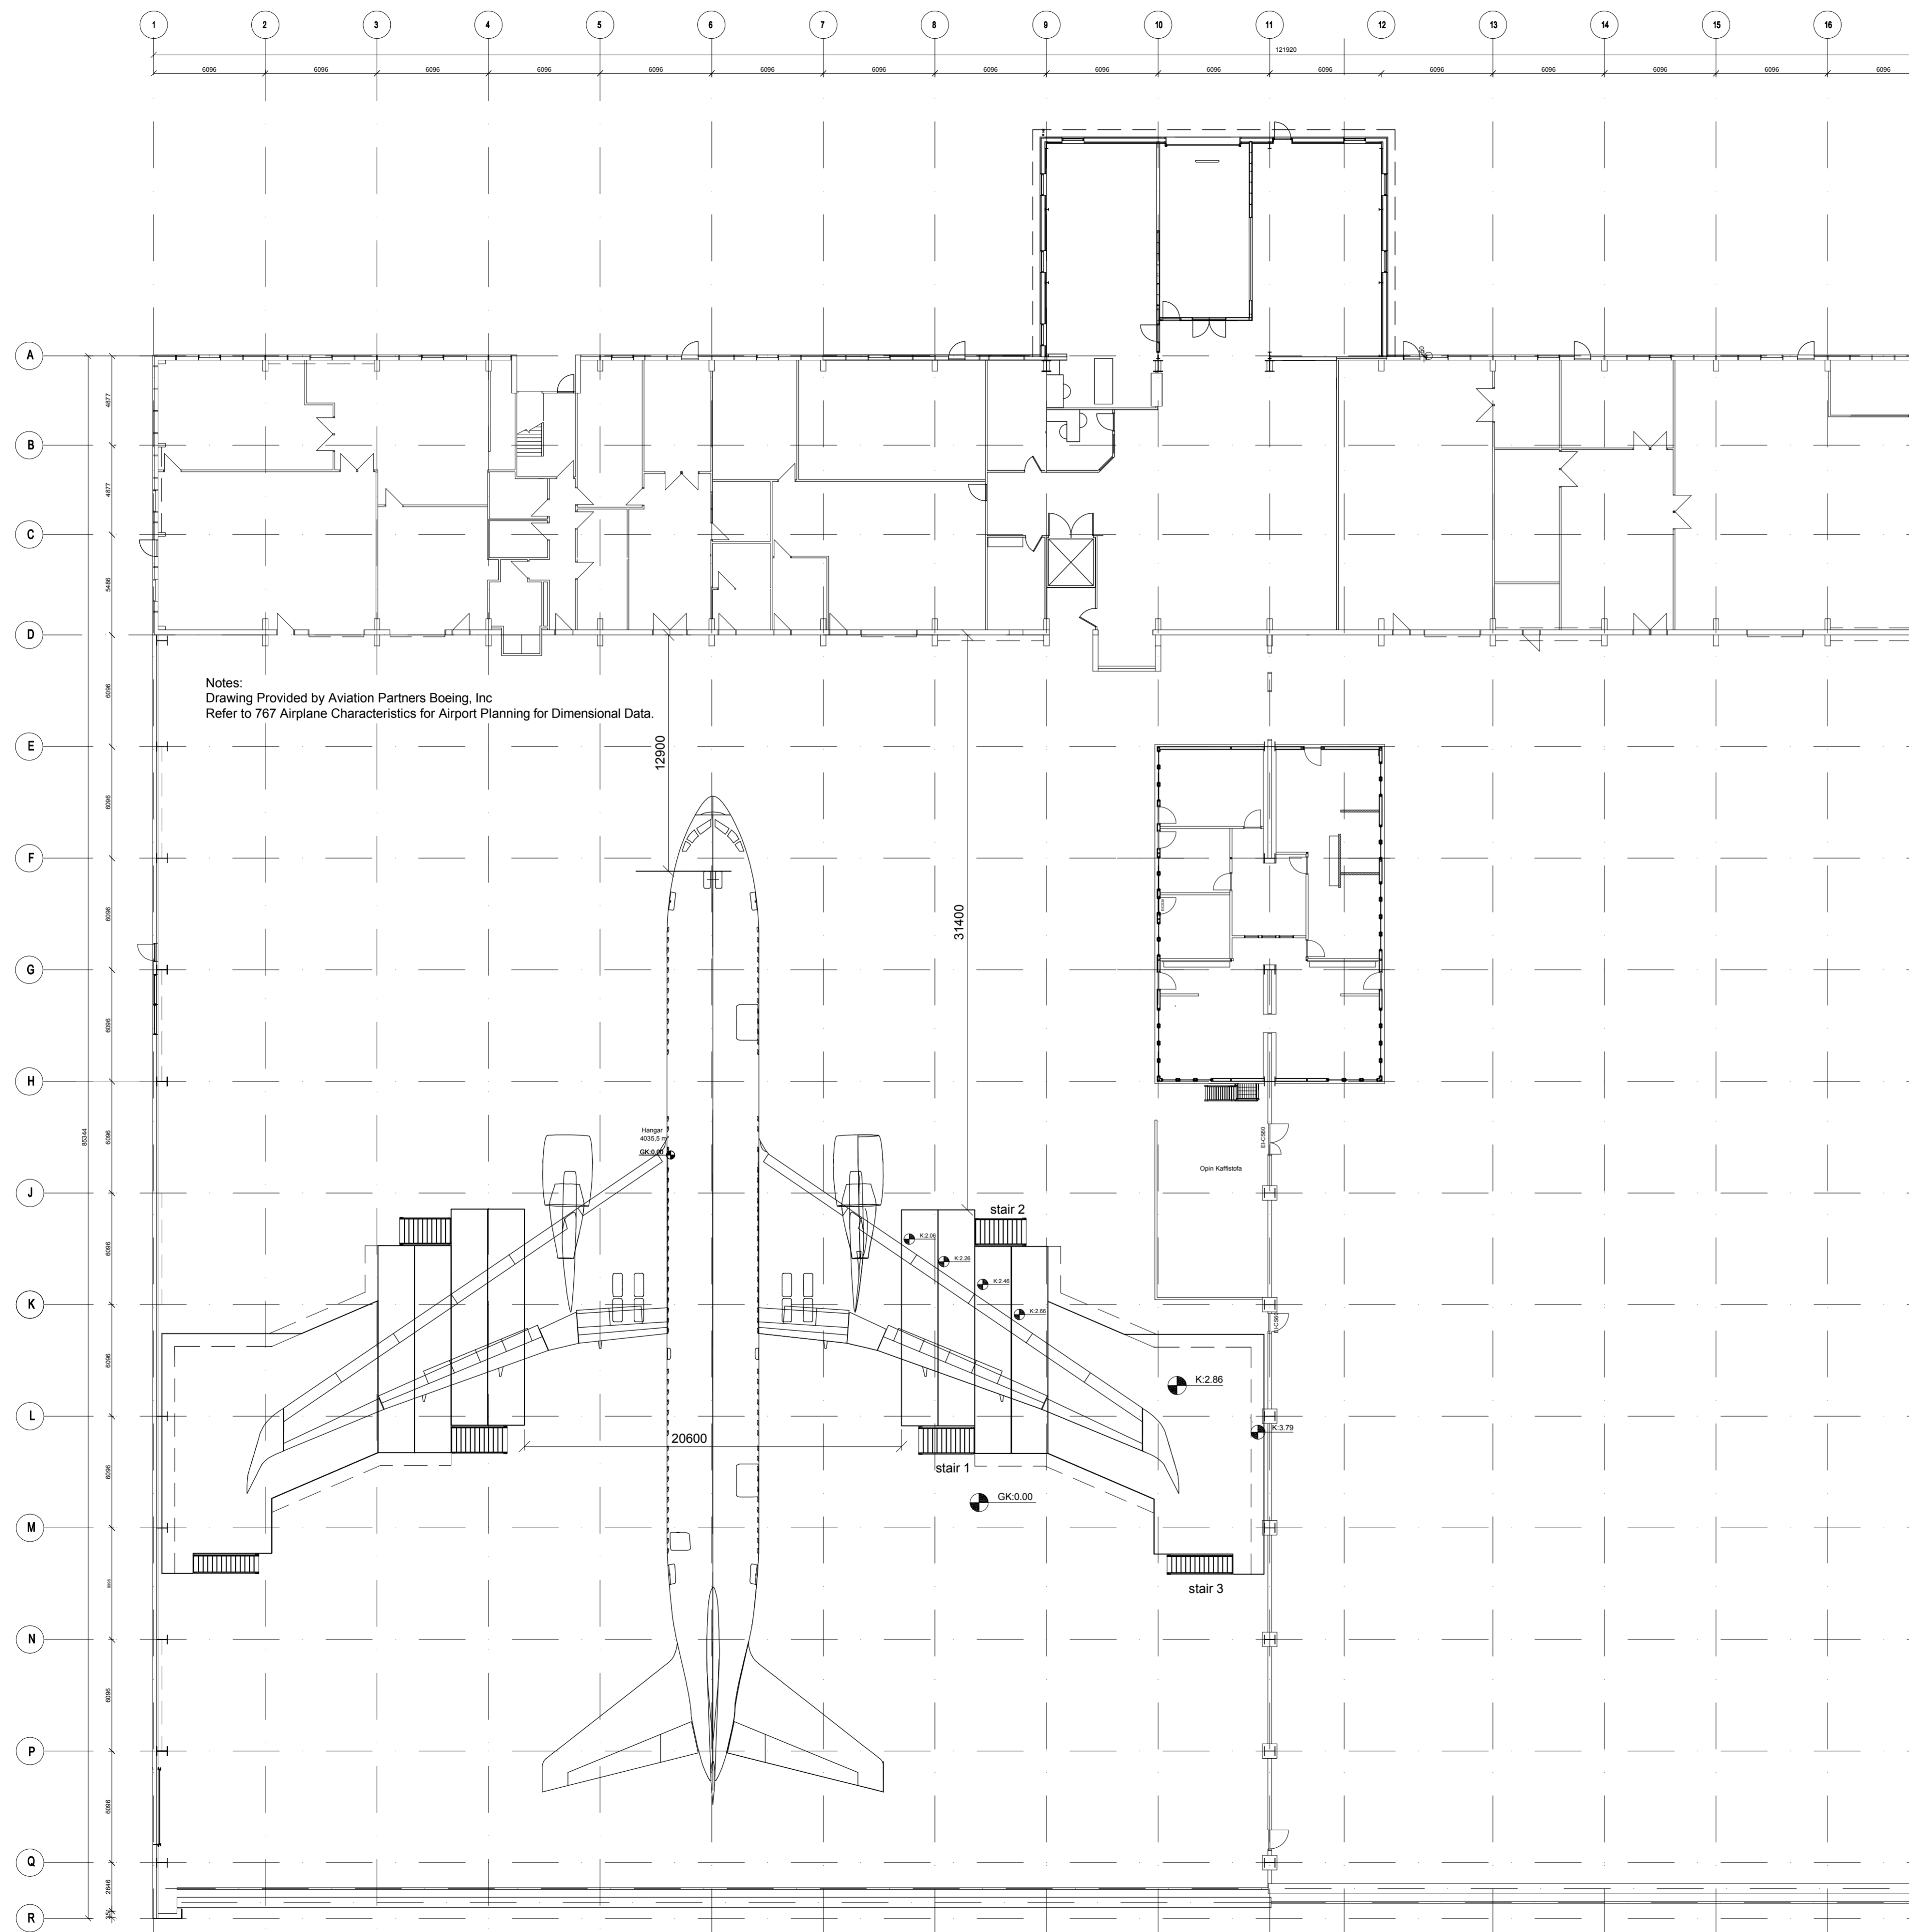


Nr.	Dags.	Breyting.	Mkv.	Dags.	Verk.nr.	Tekn.nr.	Samt.
Frumstærð blað	A:1	Minnkað í mkv.1:2	A:3	07.07.2017	VS171096		A-101
Hannað:				Teiknað:		Yfir:	
IB				IB/SV		IB	
VERKFRÆÐISTOFA SÚÐURNESJA Víkurbraut 13, 230 Reykjanesbæ Sími: 4 200 100, Fax: 4 200 111 Veffang: http://www.vss.is Netfang: vs@vss.is				Icelandair Technical Services Building 8 Keflavíkflugvelli - Column plan			
Samþ. <i>[Signature]</i> K1.130264-2639				Samræmingarhönnuður:			

Stair 3


A
104
Cut A-A
Mkv. 1:20

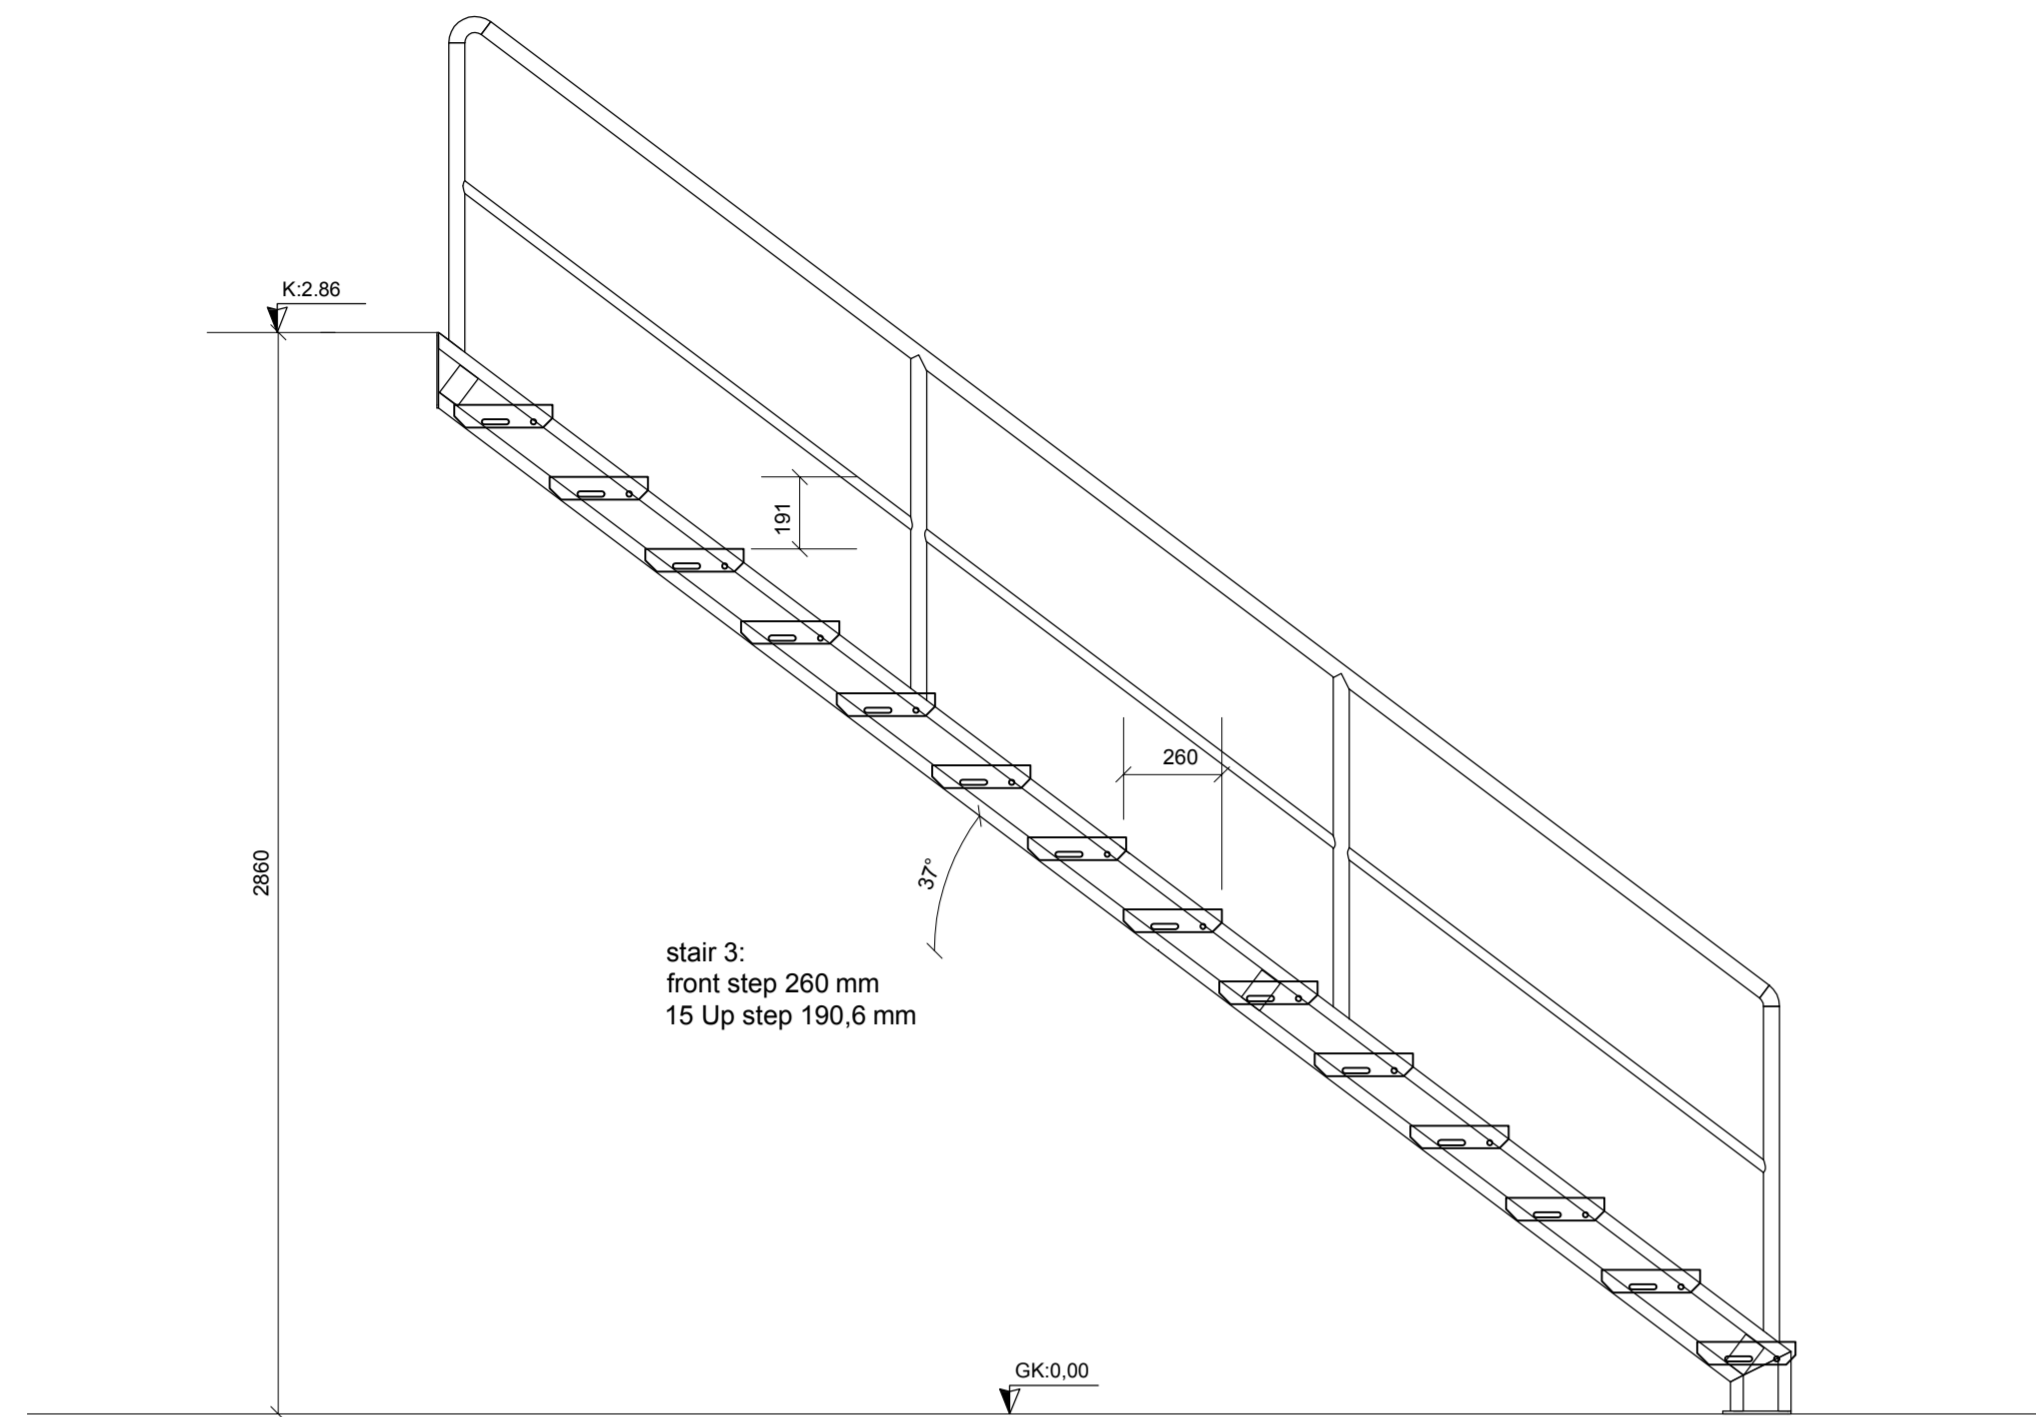

U1
104
Lineup
Mkv. 1:20

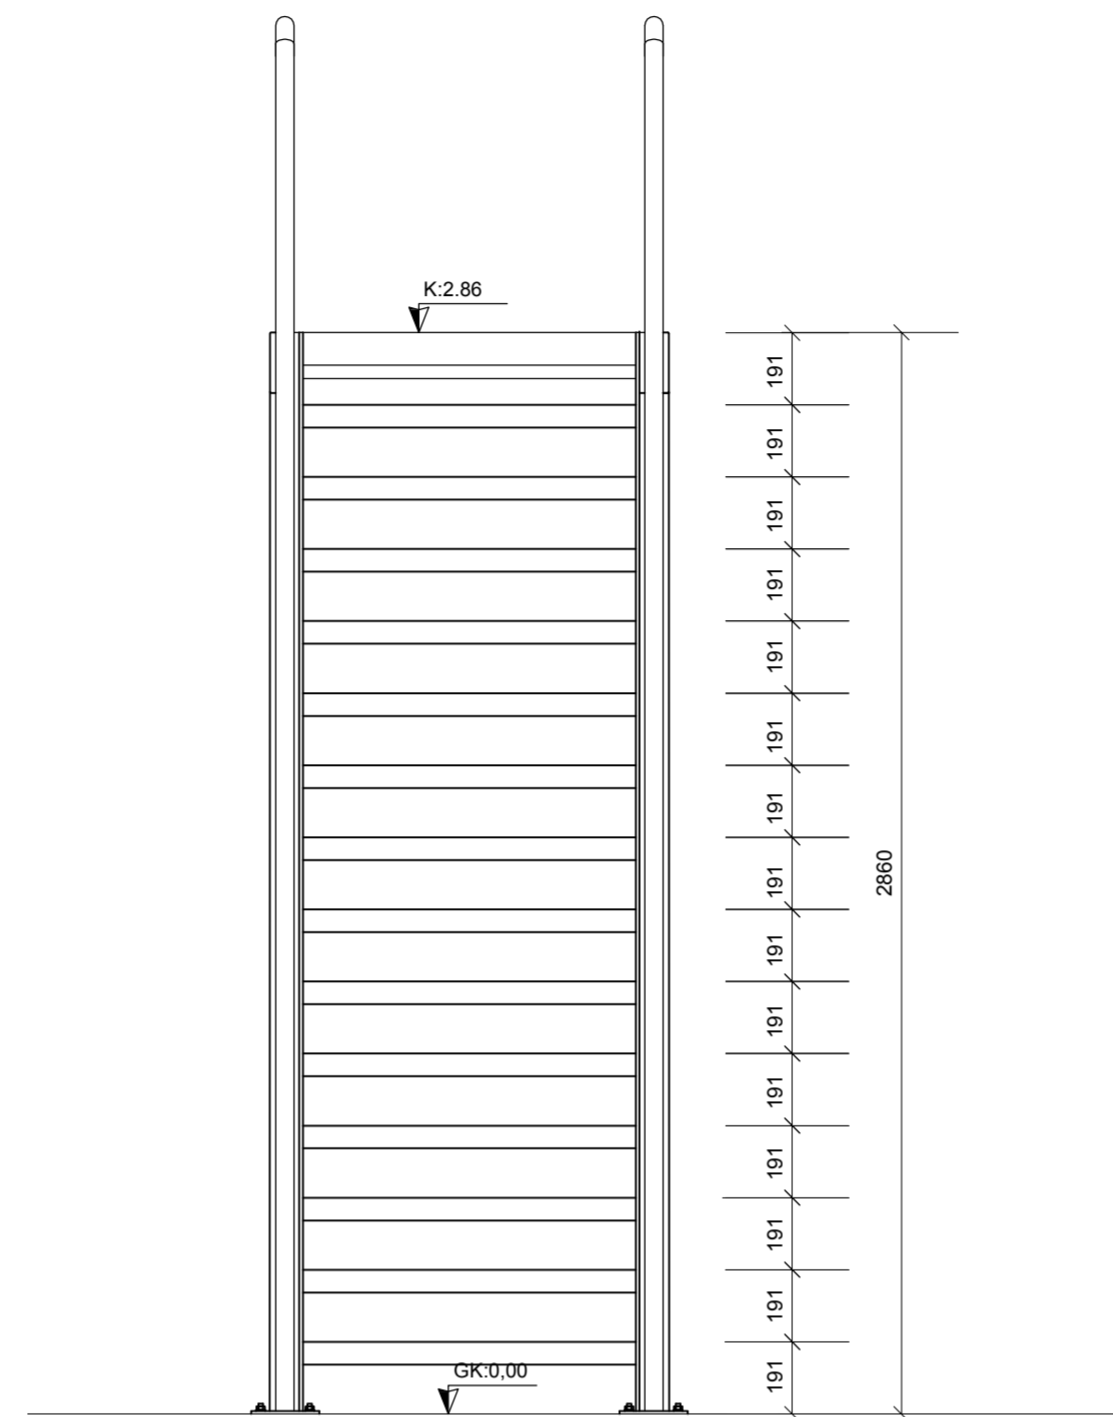


Basic image ladder
Mkv. 1:20

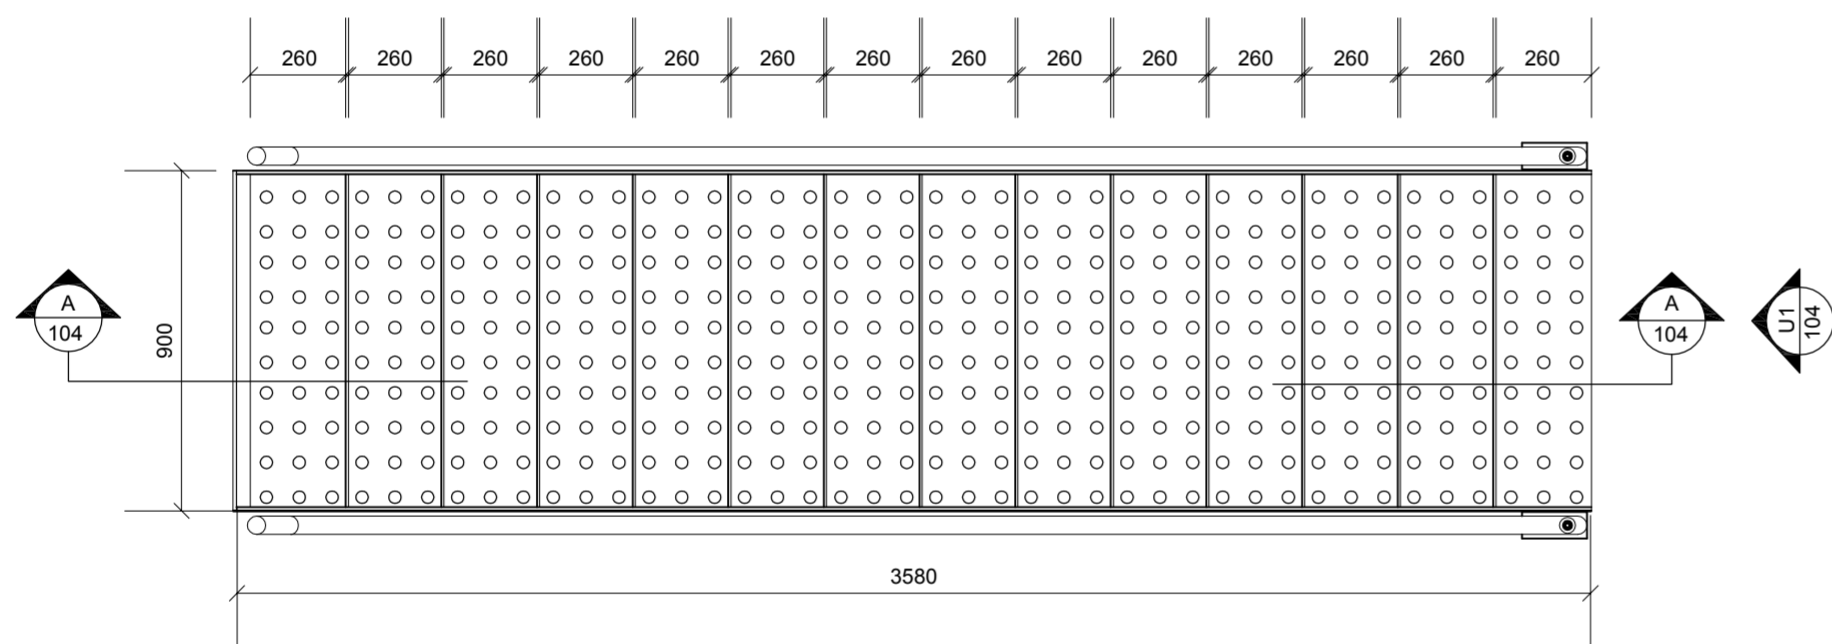

-	-	-	-	-	-	-	-	-	-
-	-	-	-	-	-	-	-	-	-
-	-	-	-	-	-	-	-	-	-
-	-	-	-	-	-	-	-	-	-
-	-	-	-	-	-	-	-	-	-
Nr.	Dags.	Breyting							Samt.
Frumstærð blaðs:	Minnkað í mkv. 1:2	Mkv.:	Dags:	Verk nr.:	Tekn. nr.:				
A:1	A:3	1:20	07.07.2017	VS171096					A-104
	Hannað:	Teiknað:	Yfir:						
	IB	IB/SV	IB						
<p>VERKFRÆÐISTOFA SUÐURNESJA Víkurbraut 13, 230 Reykjanesbæ Sími: 4 200 100, Fax: 4 200 111 Veffang: http://www.vss.is Netfang: vs@vss.is</p>			<p>Icelandair Technical Services Building 8 Keflavíkflugvelli Basic image ladder - Cut A-A - Lineup Stair 3</p>						
<p>Samp: </p>			<p>Samræmingarhönnuður: K1.130264-2639</p>						

- ALL DIMENSIONS IN MM - IF IN DOUBT ASK - DO NOT SCALE -

DRAWING SHOWN ONLY
STRUCTURE FOR ONE PLATFORM.

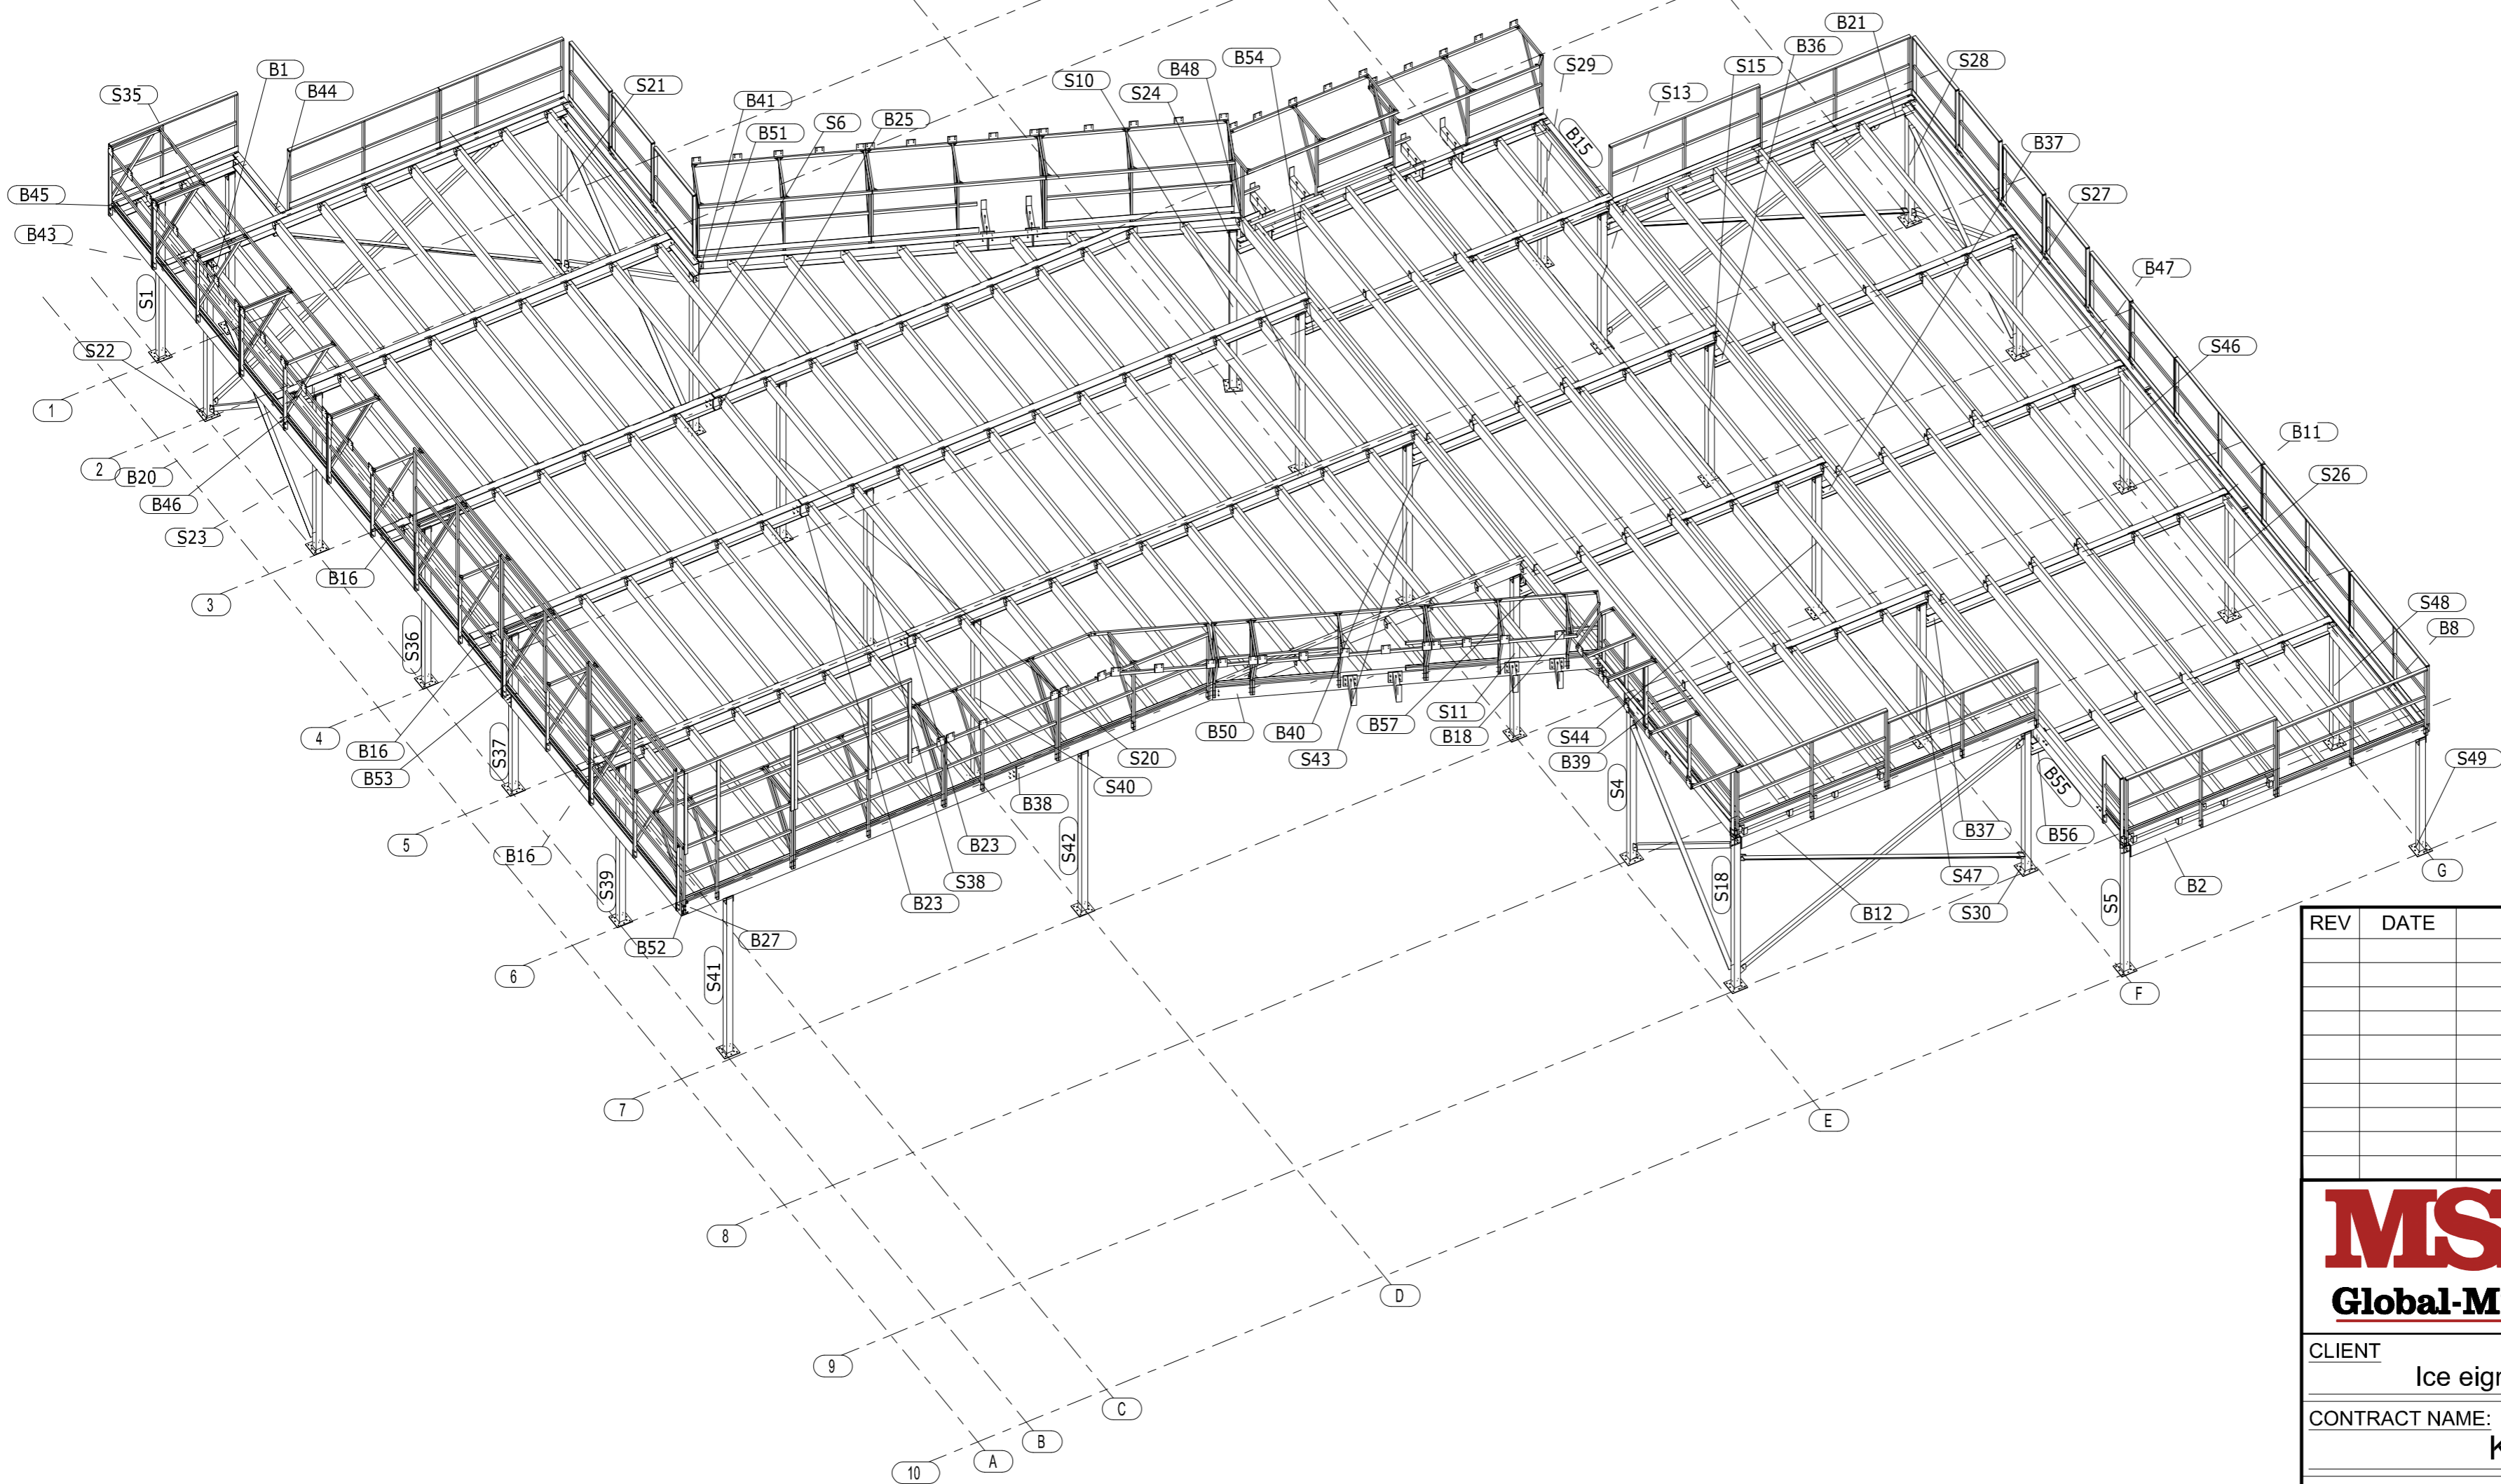

REV	DATE	DESCRIPTION	DRN	CHK'D

	Global-MSI Sp. z o.o.	tel. +48 601 428 606
	ul. Działowskiego 13 30-399 Kraków www.global-msi.pl	tel. +48 12 641 6702 fax. +48 12 641 6696 poczta@global-msi.pl

CLIENT	Ice eignir ehf	COUNTRY	Iceland
--------	----------------	---------	---------

CONTRACT NAME:
Keflavik-Falkavollur-F27-II

SITE ADDRESS:
Falkavollur 27, Sandgerdi

TITLE
**3D STRUCTURE VIEW
LEFT PLATFORM**


DRN GC	DESIGN	CHK'D
-----------	--------	-------

DATE 23.08.2017	PROJECT TYPE. CANOPY	SCALE 1: @ A2
--------------------	-------------------------	------------------

DRG No.	34120-04	REV
---------	----------	-----

- ALL DIMENSIONS IN MM - IF IN DOUBT ASK - DO NOT SCALE -

DRAWING SHOWN ONLY
STRUCTURE FOR ONE PLATFORM.

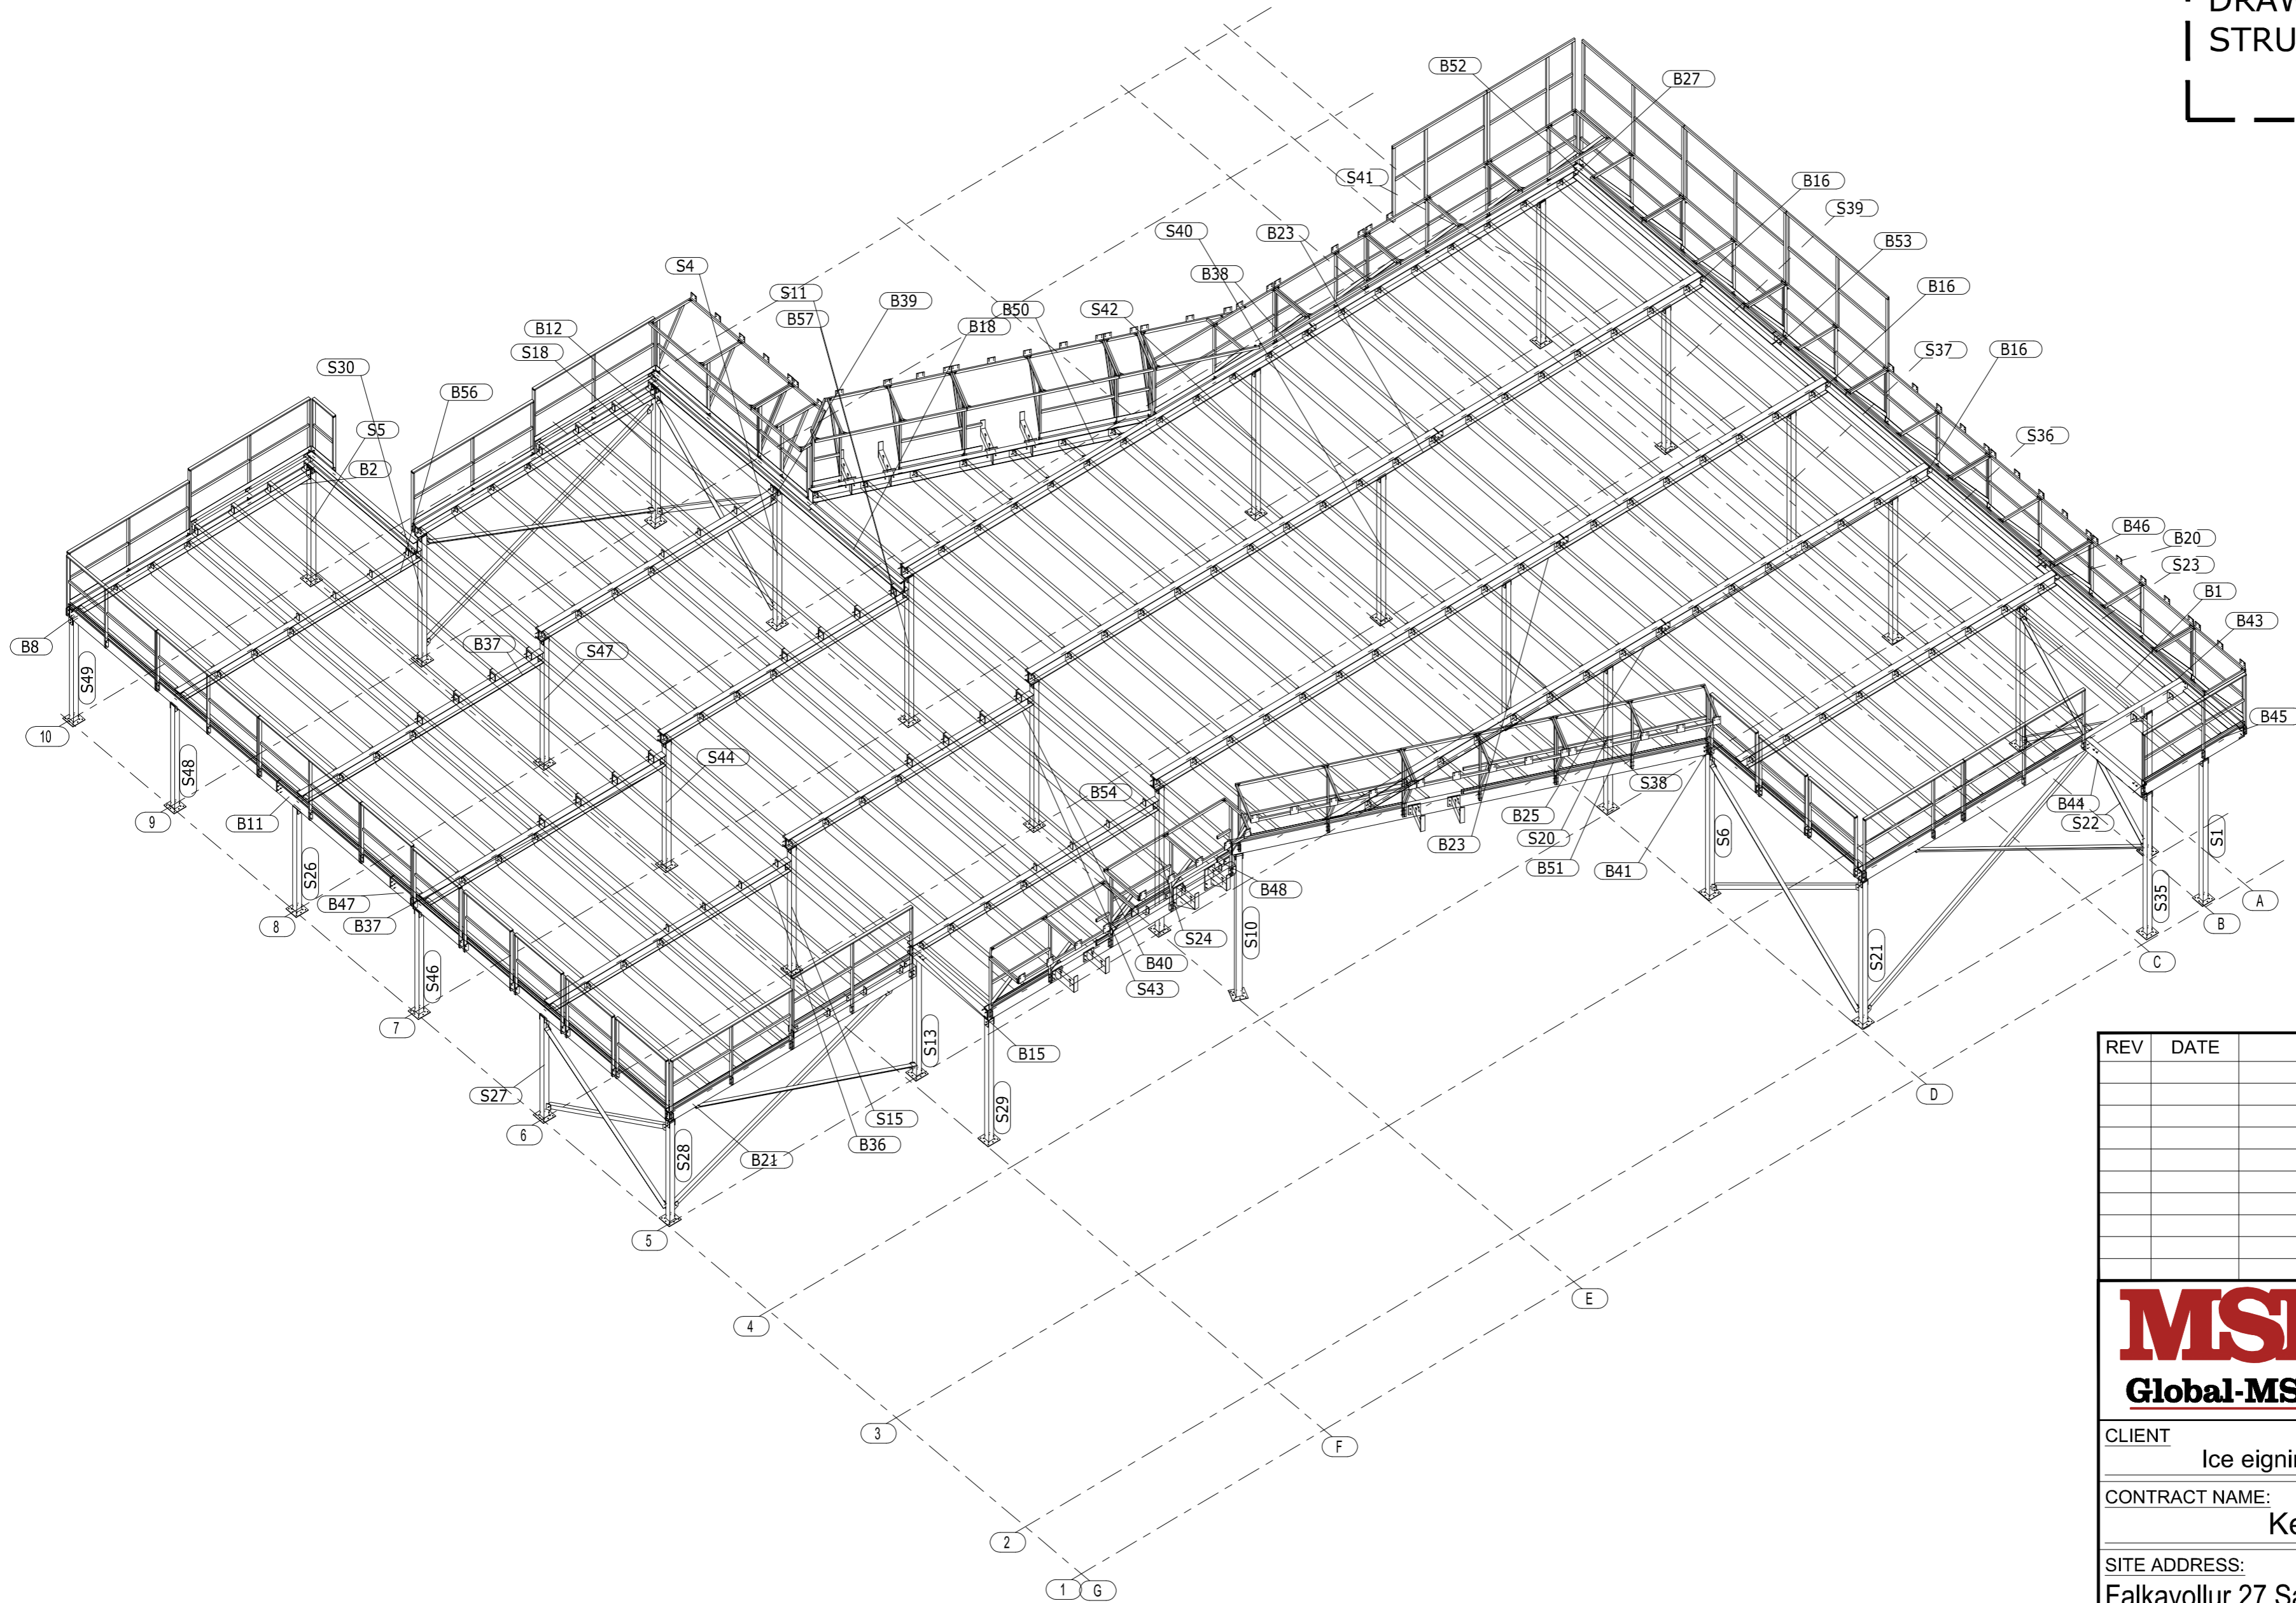

REV	DATE	DESCRIPTION	DRN	CHK'D

	Global-MSI Sp. z o.o.	tel. +48 601 428 606
	ul. Działowskiego 13 30-399 Kraków www.global-msi.pl	tel. +48 12 641 6702 fax. +48 12 641 6696 poczta@global-msi.pl

CLIENT	Ice eignir ehf	COUNTRY	Iceland
--------	----------------	---------	---------

CONTRACT NAME:
Keflavik-Falkavollur-F27-II

SITE ADDRESS:
Falkavollur 27, Sandgerdi

TITLE
3D STRUCTURE VIEW
LEFT PLATFORM






DRN GC	DESIGN	CHK'D
-----------	--------	-------

DATE 23.08.2017	PROJECT TYPE. CANOPY	SCALE 1: @ A2
--------------------	-------------------------	------------------

DRG No. 34120-05	REV
---------------------	-----

- ALL DIMENSIONS IN MM - IF IN DOUBT ASK - DO NOT SCALE -

DRAWING SHOWN ONLY
STRUCTURE FOR ONE PLATFORM.

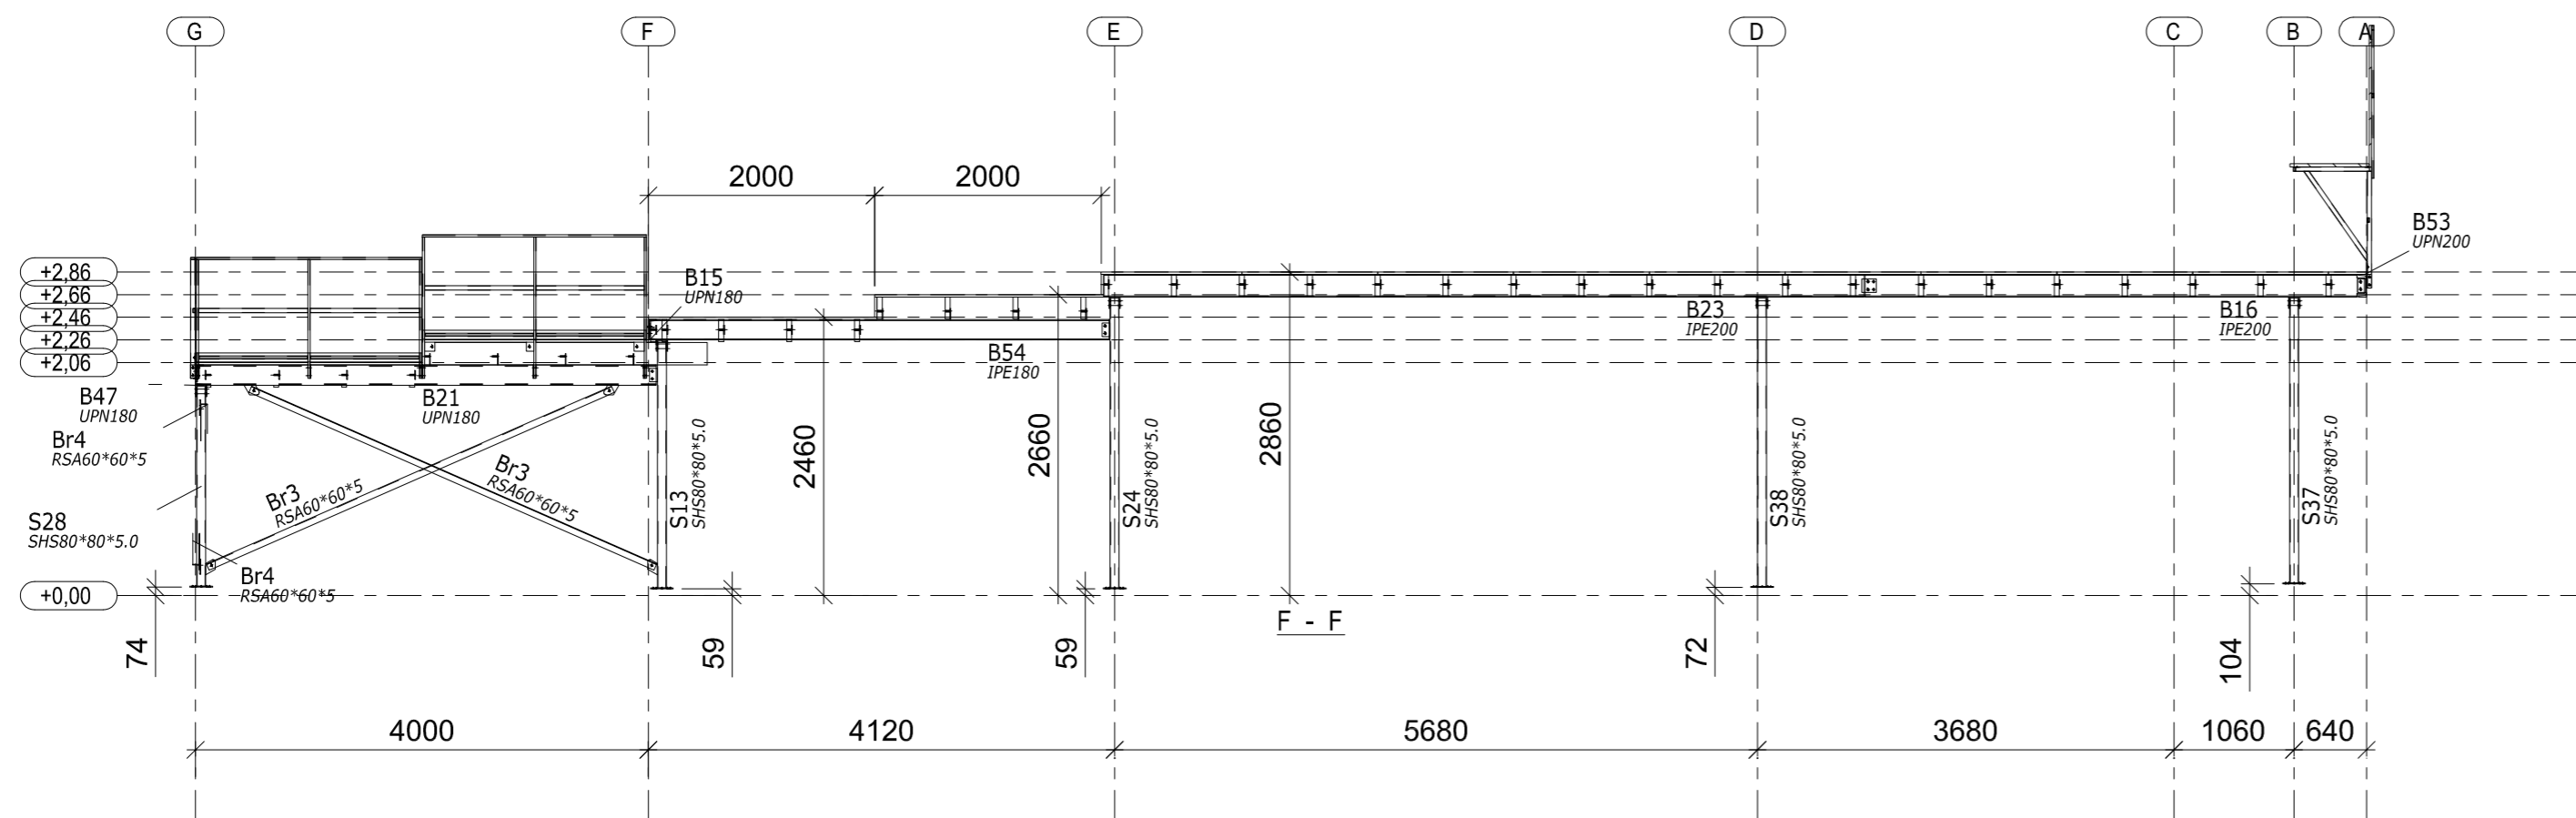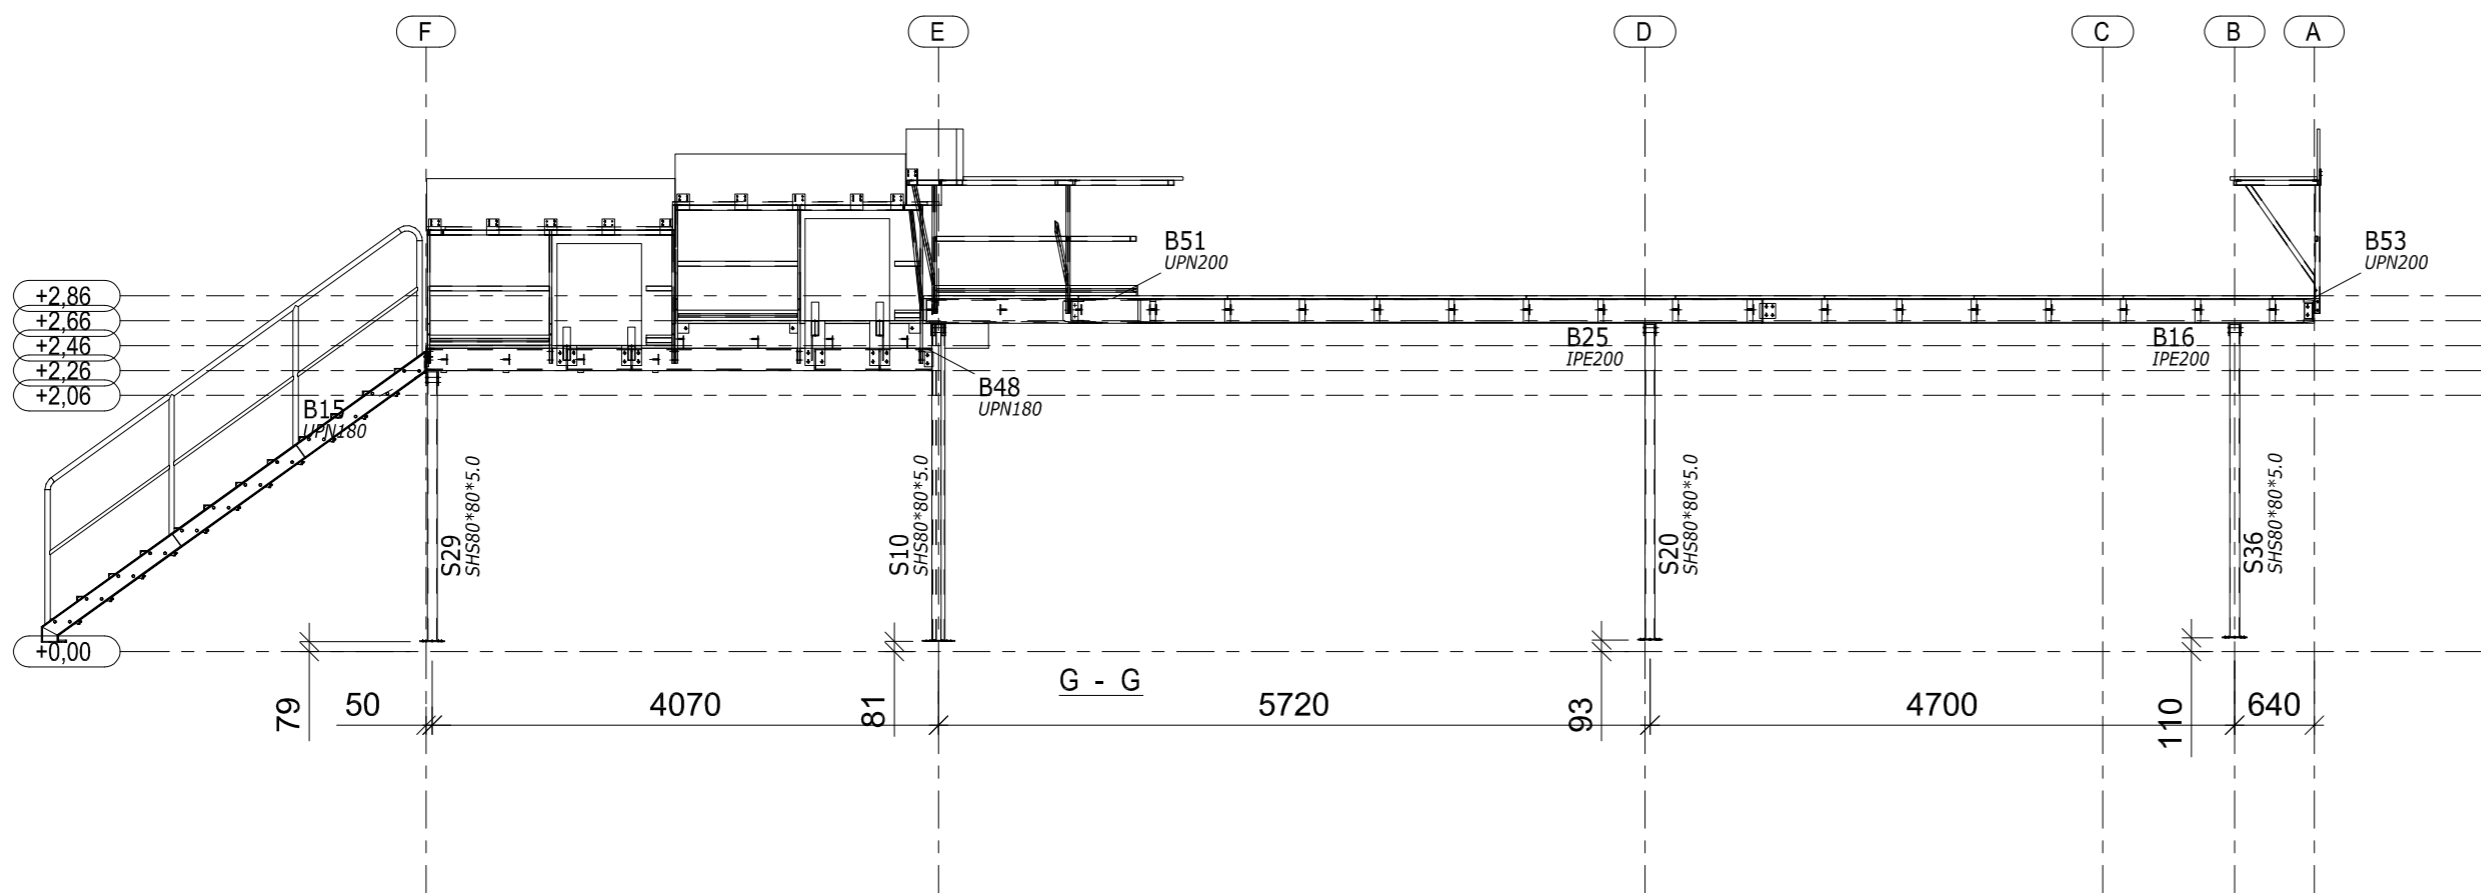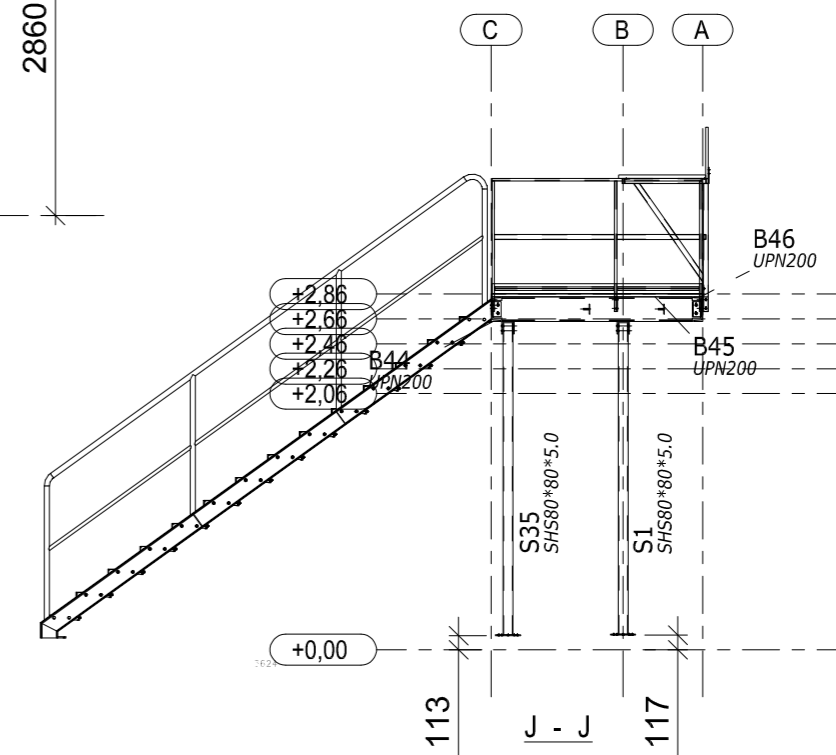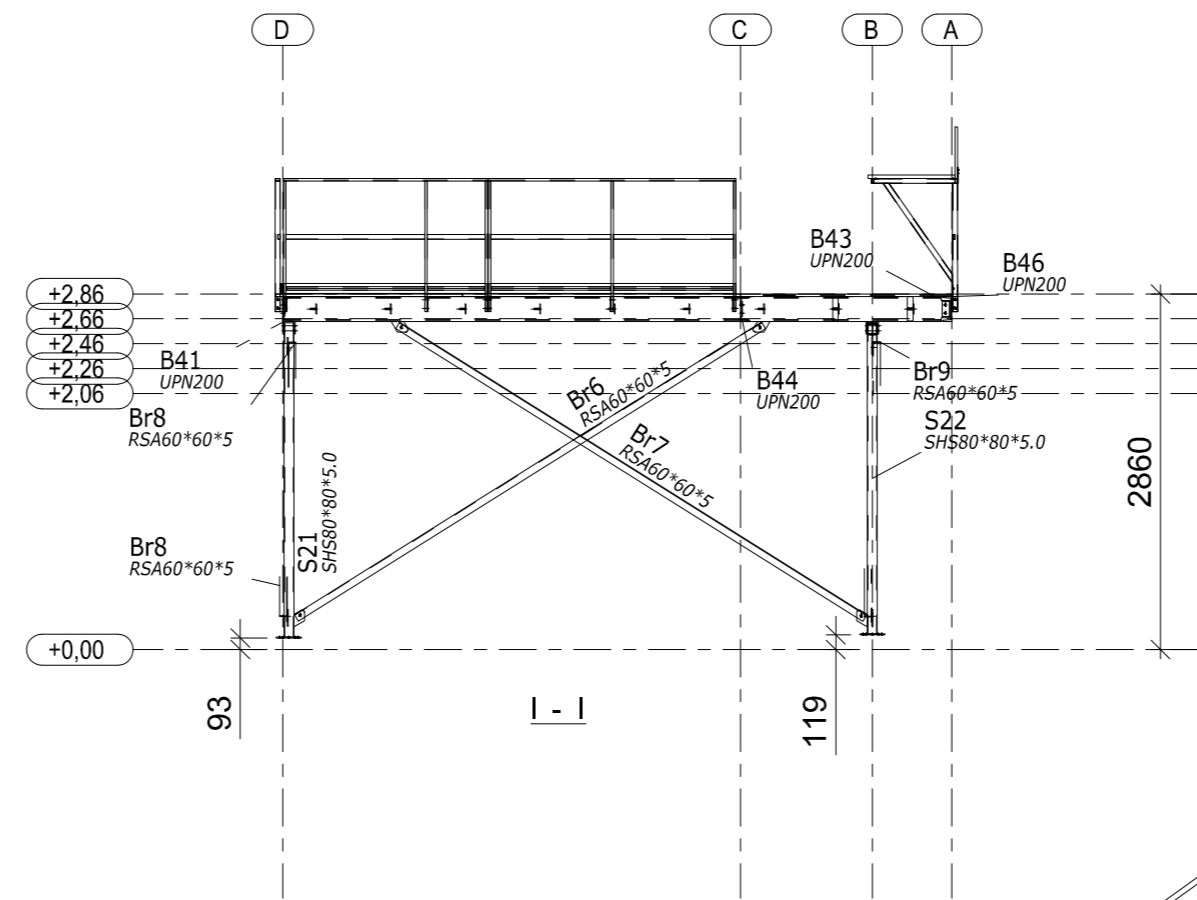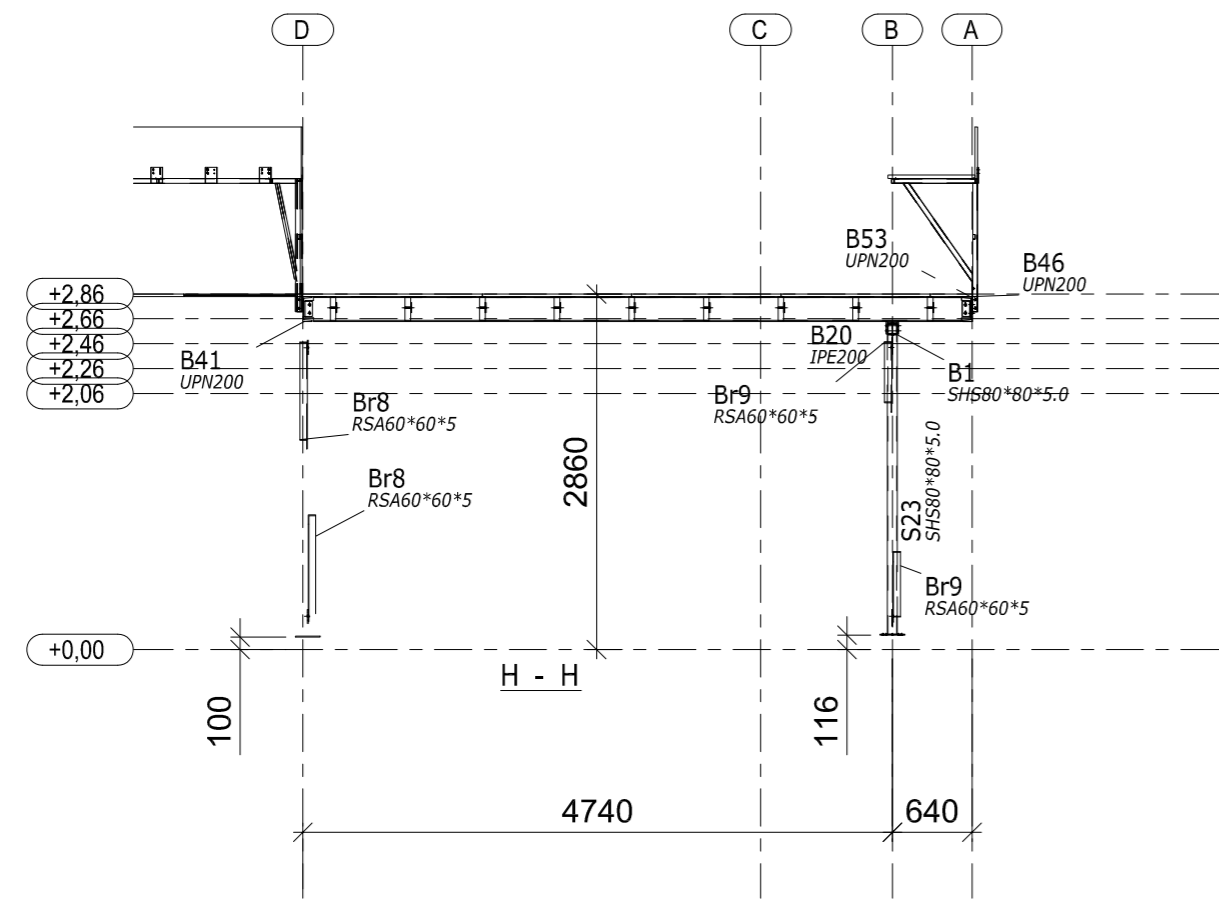

REV	DATE	DESCRIPTION	DRN	CHK'D

	Global-MSI Sp. z o.o.	tel. +48 601 428 606
	ul. Działowskiego 13 30-399 Kraków www.global-msi.pl	tel. +48 12 641 6702 fax. +48 12 641 6696 poczta@global-msi.pl

CLIENT	Ice eignir ehf	COUNTRY	Iceland
--------	----------------	---------	---------

CONTRACT NAME:
Keflavik-Falkavollur-F27-II

SITE ADDRESS:
Falkavollur 27, Sandgerdi


TITLE
SECTIONS
LEFT PLATFORM

DRN GC	DESIGN	CHK'D
-----------	--------	-------

DATE 23.08.2017	PROJECT TYPE. CANOPY	SCALE 1: @ A2
--------------------	-------------------------	------------------

DRG No. 34120-07	REV
---------------------	-----


Air pressure- & Ventilation pipes - Floor plan, 1:50

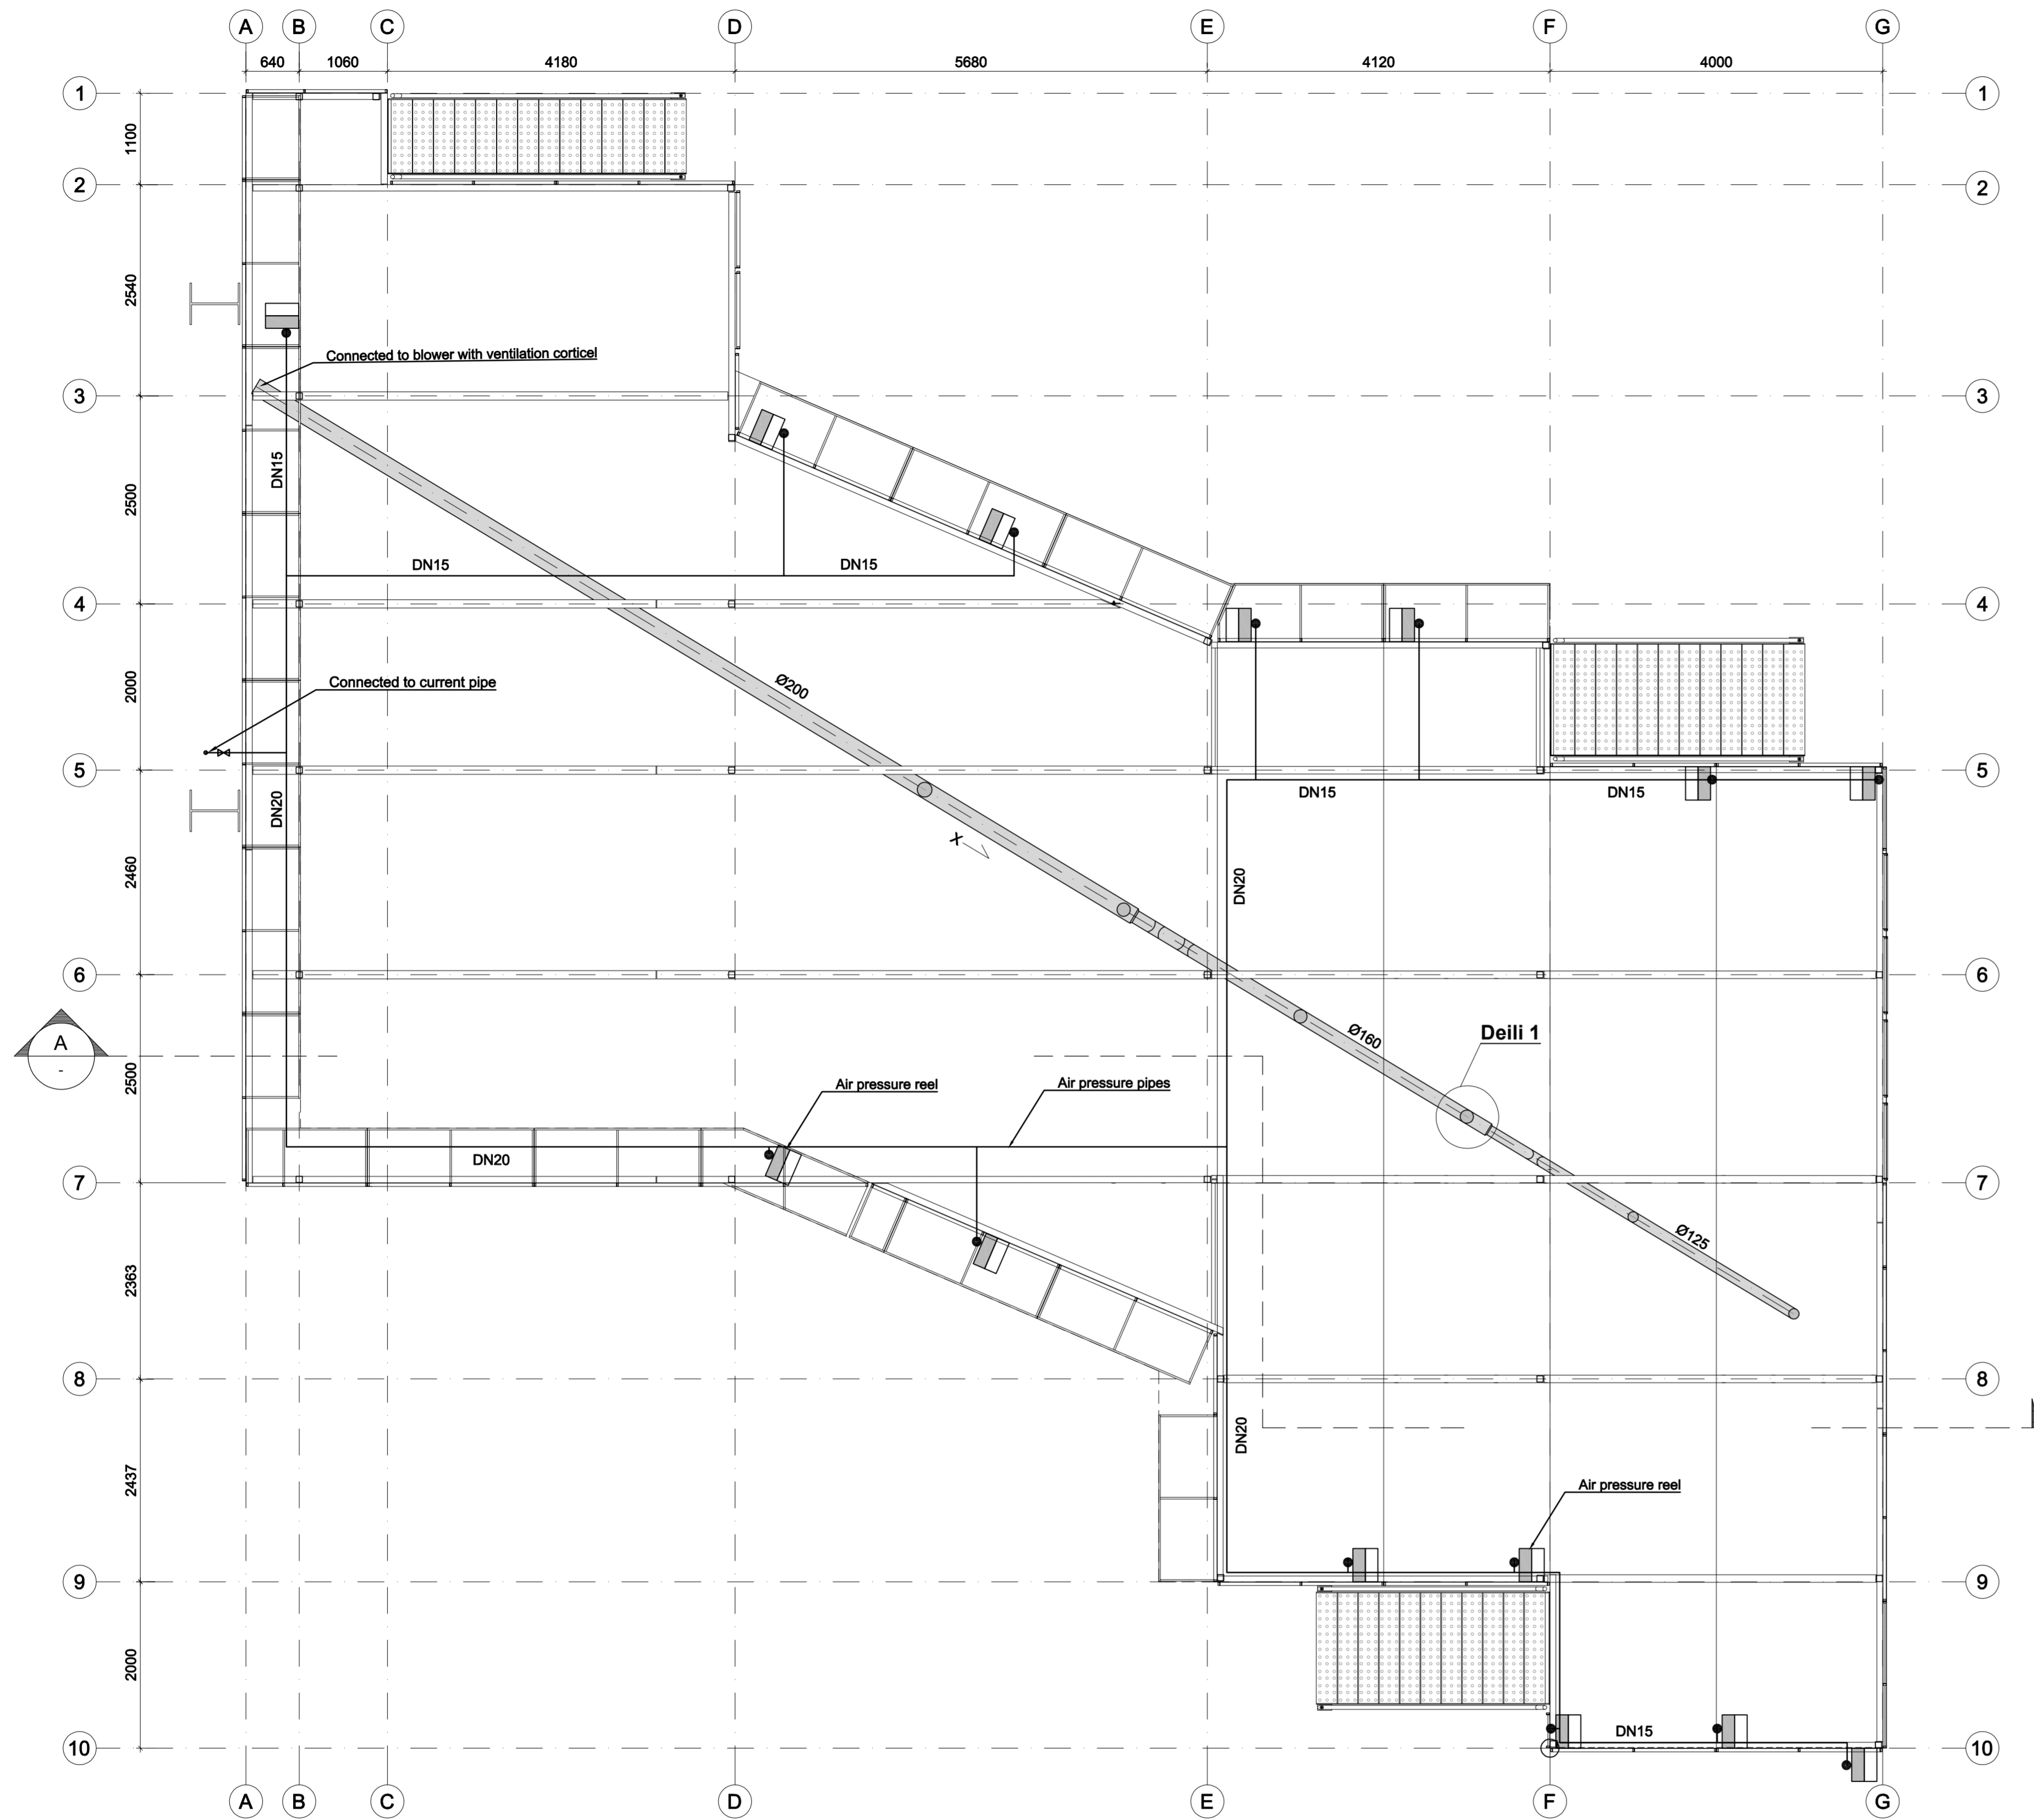

Key plan




1 Detail 1:10

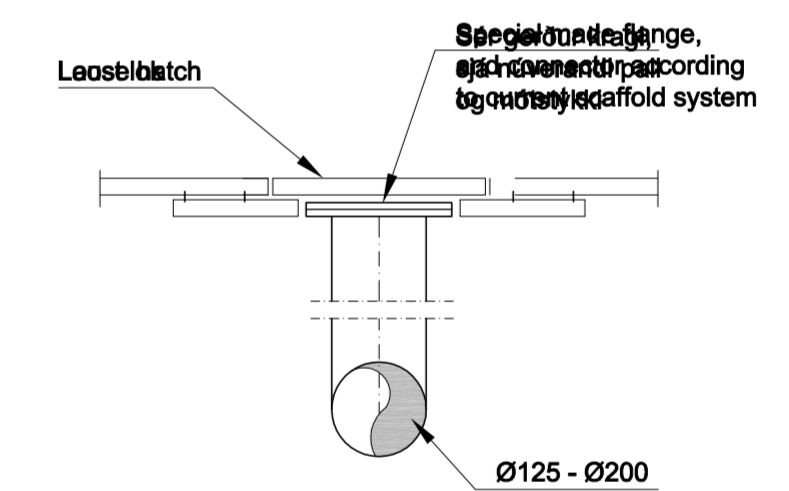

Notes:


Air pressure pipes shall be galvanized steel pipes, GIRAIR or similar approved air pressure pipes, certified by Brunamálastofnun, laid under wing scaffold floor.
Quick connectors shall be at all connecting places and draining valve at lowest points.

A Section 1:10

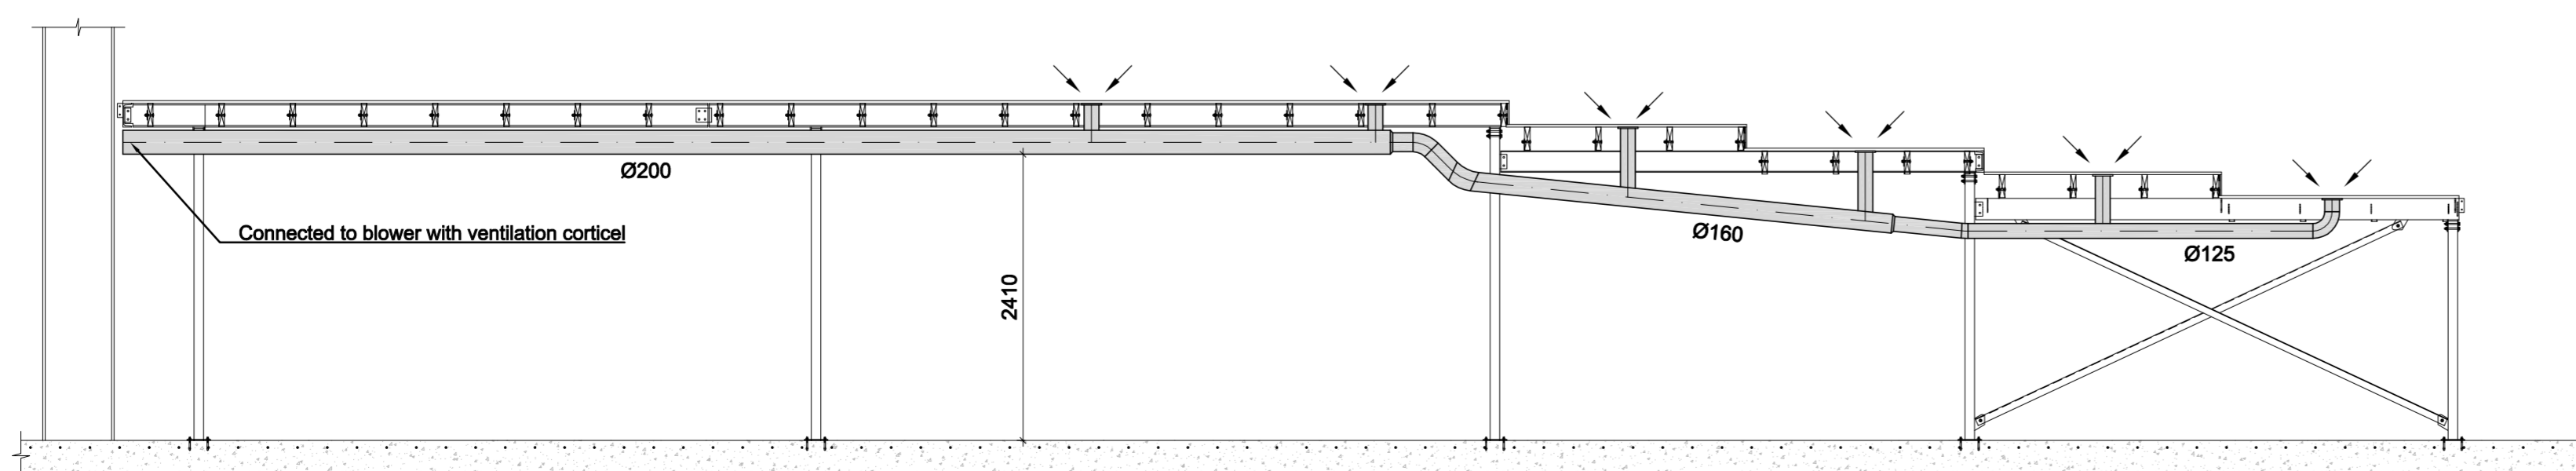

No.	Date	Changes	Appr.
-	-	-	-
-	-	-	-
-	-	-	-
-	-	-	-
-	-	-	-
No.	Date	Changes	Appr.
Primary paper size	Reduced scale	Scale	Date
A:1	A:3	1:50, 1:10	07.07.2017
Designed by:	Drawn by:	Reviewed by:	Project no.:
MG/SA	MG/SV	MG/SA	VS171096
VERKFRÆÐISTOFA SUBURNESJA Víkurbraut 13, 230 Reykjavík Tel: 4 200 100, Fax: 4 200 111 Website: http://www.vss.is Email: vs@vss.is			Drawing no.: P-101 e
Icelandair Technical Services Building 8 Keflavíkurflugvelli			Wing scaffold - Airpressure & Ventilation pipes Floor plan - section cut - Detail
Approved:	Coordinate designer:	k1.090858-3249 k1.130264-25	

Electrical wiring - Basic image, 1:50

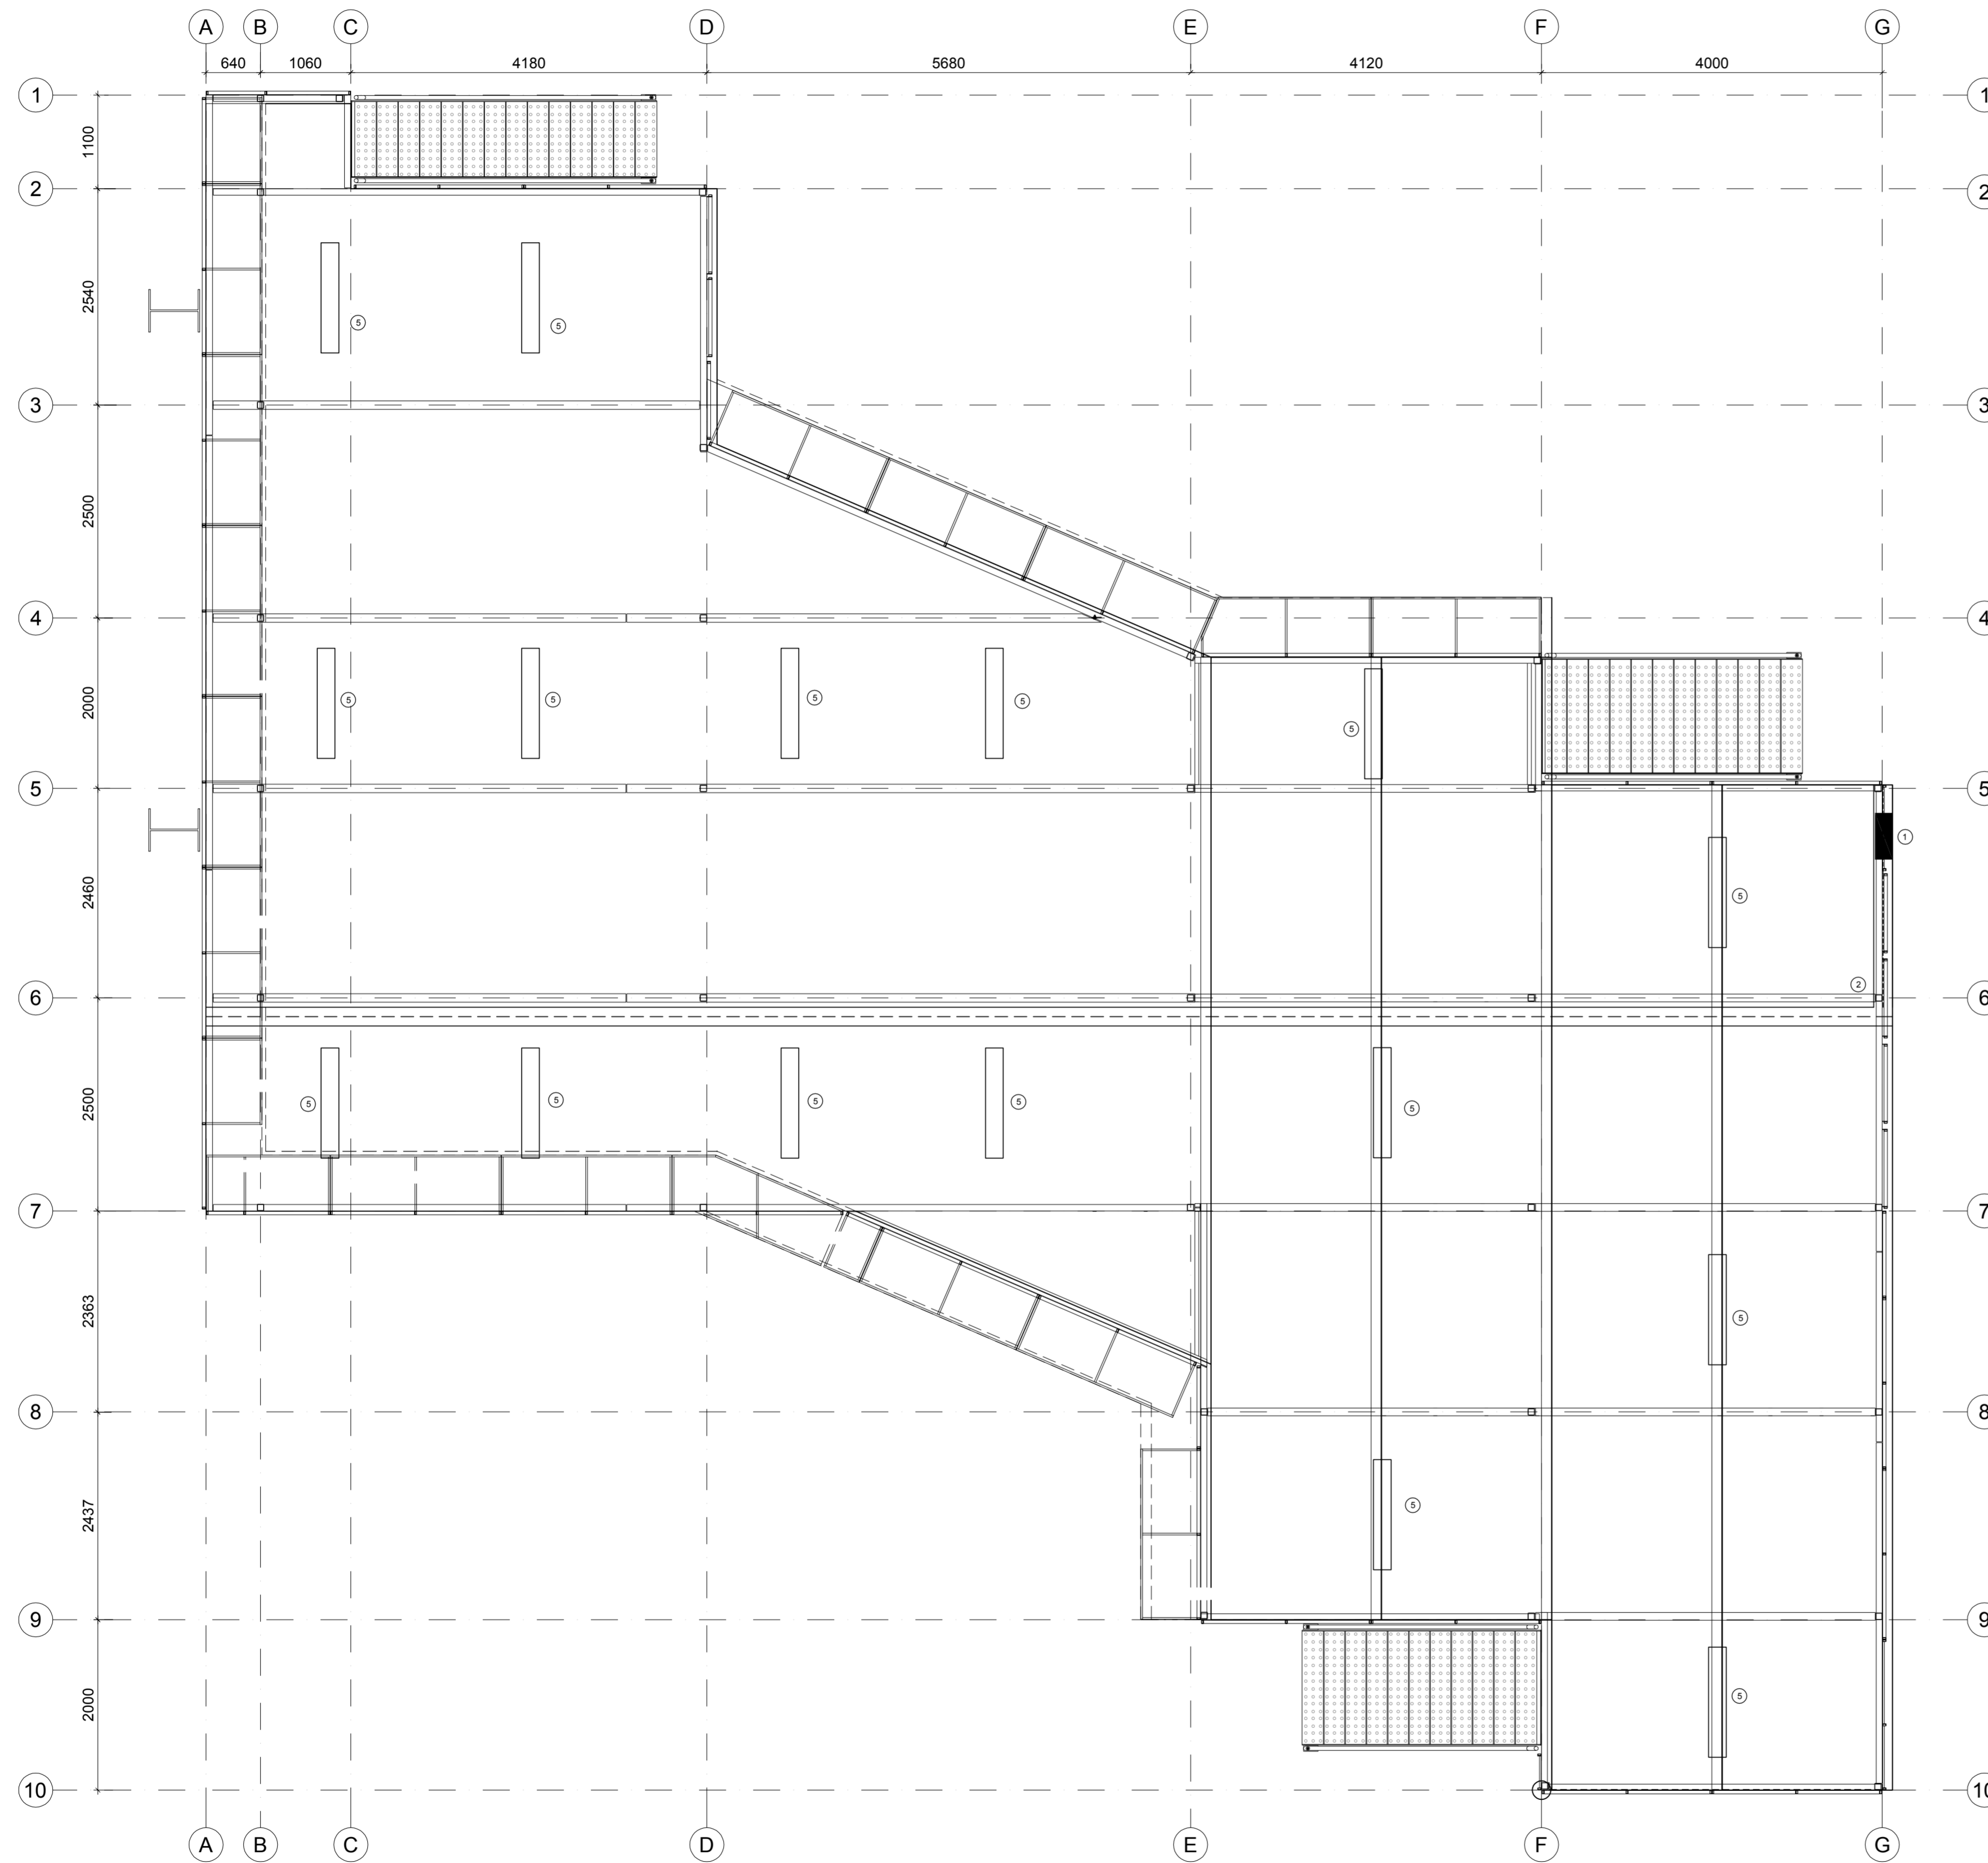

Lykilmynd




- ① Main TP 1.1
- ② Cable tray 200mm
- ③ Plastic cable tray mounted on the back of the table
- ④ Working lights under the wing, supplied by owner
- ⑤ LED lights 1293x200mm
- ⑥ Socket for cable roller
- ⑦ Internet connection



Nr.	Dags.	Breyting.	Mkv.	Dags.	Verk.nr.	Tekn.nr.	Samt.
Frumstærð blað:	A:1	Minnkað í mkv:1:2	A:3	04.07.2017	VS171096	R-101	
Hannað:	GL	Teknað:	GL/SV	Yfir:	IBG		
VERKFRÆÐISTOFA SUÐURNESJA Víkurbraut 13, 230 Reykjavík Sími: 4 200 100, Fax: 4 200 111 Veffang: http://www.vss.is Netfang: vs@vss.is				Icelandair Technical Services Bygging & Keflavíkurflugvelli Steel platform - Wiring Low tension and light under the platform			
Samþ. <i>[Signature]</i> kt.281049-3489				Samræmingarhönnuður:			

Electrical wiring - Basic image, 1:50

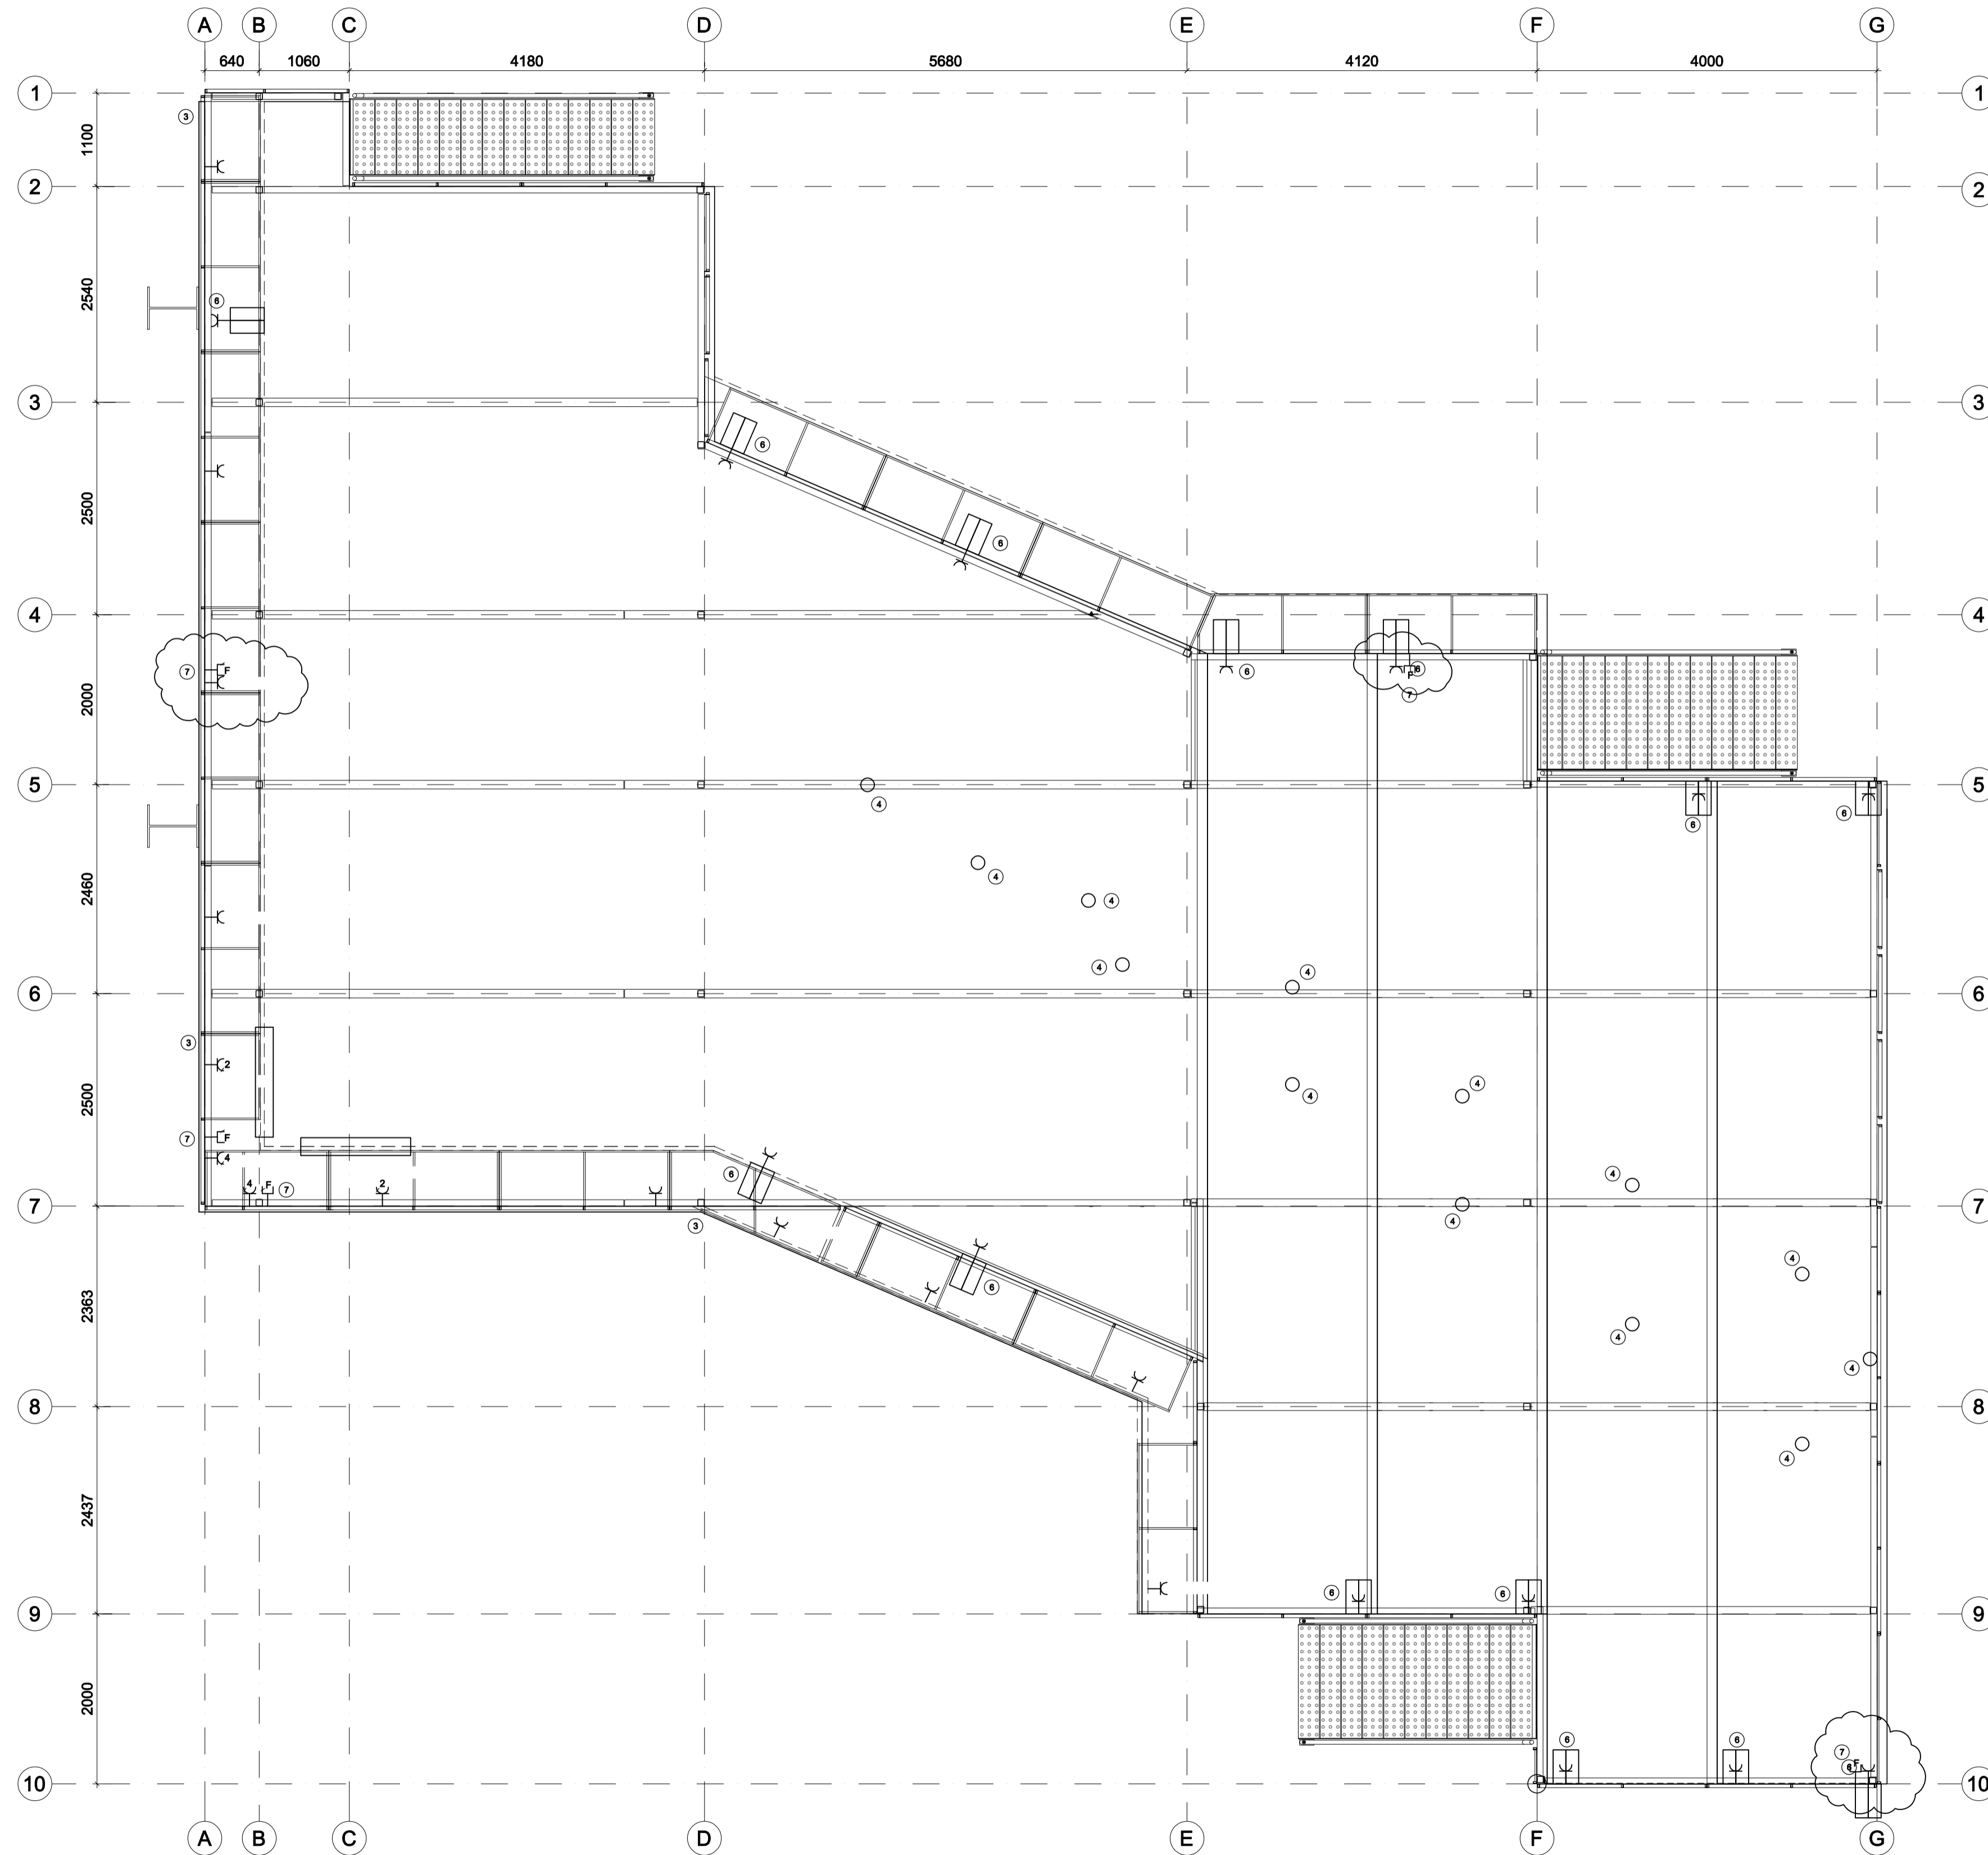

Lykilmynd




- ① Main TP 1.1
- ② Cable tray 200mm
- ③ Plastic cable tray mounted on the back of the table
- ④ Working lights under the wing, supplied by owner
- ⑤ LED lights 1293x200mm
- ⑥ Socket for cable roller
- ⑦ Internet connection



-	-	-	-	-	-	-	-
-	-	-	-	-	-	-	-
-	-	-	-	-	-	-	-
-	-	-	-	-	-	-	-
A	27.09.2017	Increase the nr of internet connection					GL
Nr.	Dags.	Breyting					Samþ.
Furmatarnó blaðs	Mínikað í mív.1-2	Mkv.:	Dags.:	Verk.nr.:	Telkn.nr.:		
A:1	A:3	1:50	04.07.2017	VS171096	R-102		
			Hannað:	Teiknað:	Yfir:		
			GL	GL/SV	IBG		
VERKFRÆÐISTOFA SUDURNESJA Víkurbraut 13, 230 Reykjanesbæ Sími: 4 200 100, Fax: 4 200 111 Veffang: http://www.vss.is Netfang: vs@vss.is				Icelandair Technical Services Bygging & Keflavíkurflugvelli Steel platform - Wiring Low tension and light under the platform			
Samþ.: <i>[Signature]</i> k:281049-3489				Samræmingarhönnuður:			

Electrical box "TP"
 Box size: H600xB800xD275
 3N ~ 400/230V 50Hz

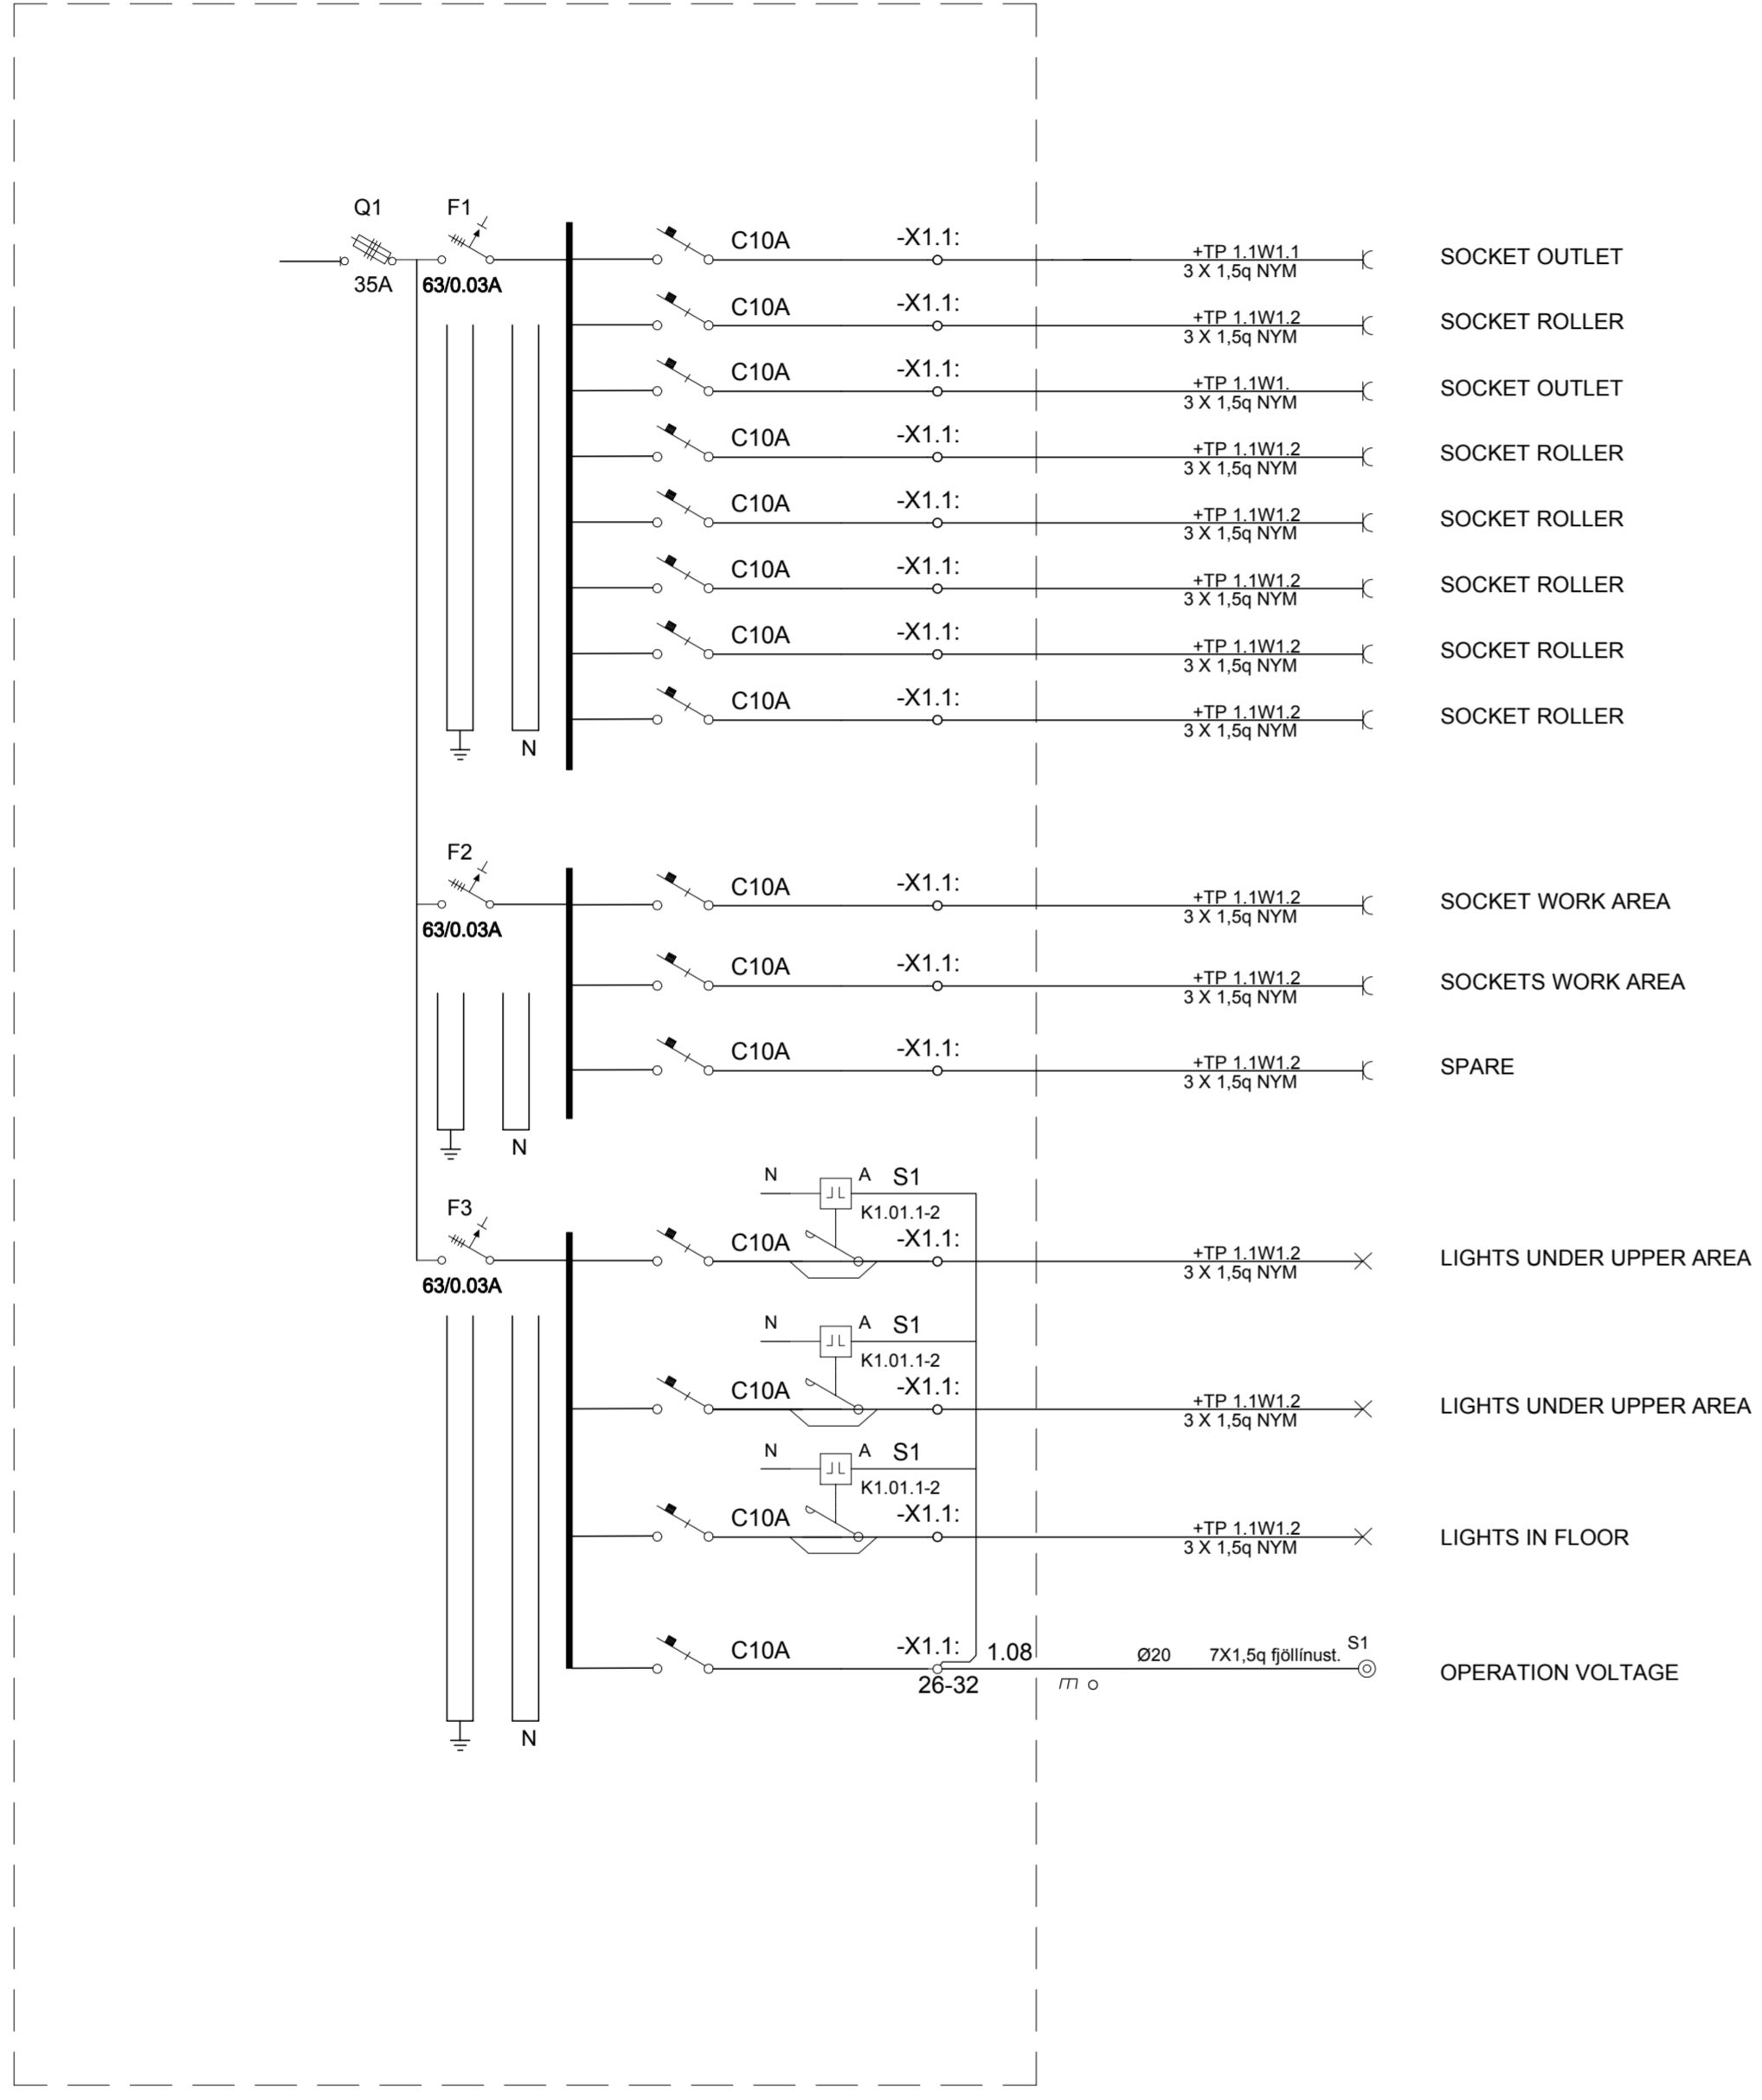

- ① Main TP 1.1
- ② Cable tray 200mm
- ③ Plastic cable tray mounted on the back of the table
- ④ Working lights under the wing, supplied by owner
- ⑤ LED lights 1293x200mm
- ⑥ Socket for cable roller
- ⑦ Internet connection



Nr.	Dags.	Breyting	Samt.	
Frumstærð blað:	Minnkað í mkr:1:2	Mkr:	Dags:	Verk.nr.:
A:1	A:3	enginn	04.07.2017	VS171096
Hannað:		Teiknað:	Yfir:	R-103
GL		GL/SV	IBG	
VERKFRÆÐISTOFA SUBURNESJA Víkurbraut 13, 230 Reykjavík Sími: 4 200 100, Fax: 4 200 111 Veffang: http://www.vss.is Netfang: vs@vss.is			Icelandair Technical Services Bygging & Keflavíkurflugvelli Steel platform - Wiring Low tension and light under the platform	
Samþ: <i>[Signature]</i> kt.281049-3489			Samræmingarhönnuður:	